


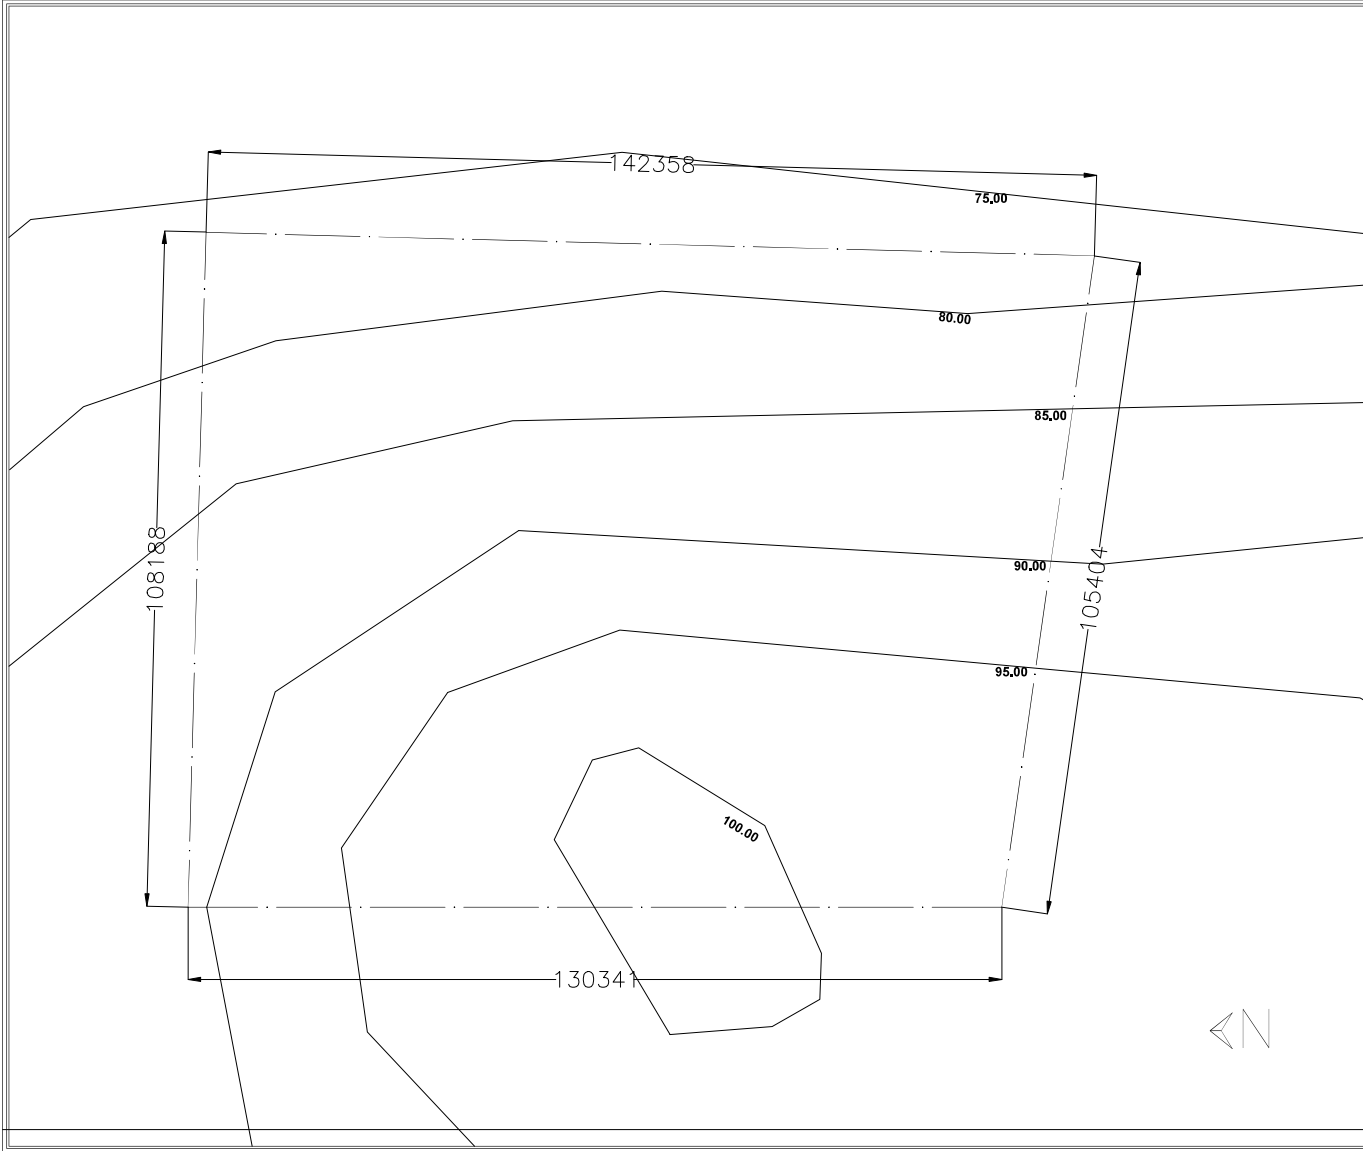

PROJECT TITLE :-
**PROPOSED CONVENTION CENTER AT
JONGLAPARA LOCALITY AT
RESUBELPARA, NORTH GARO HILLS,
MEGHALAYA-PHASE I**

CLIENT:
MEGHALAYA AGE LIMITED

FOR APPROVAL	RO		

DRAWING TITLE
CONTOUR LAYOUT

DRAWING NO. :-
AR24/MAL/C8/ROM/AR-01A

SHEET NO.
AR-01A

SCALE: **NTS**

DATE:
23.09.24


REVISION NO. :-0

DRAWN BY:

DESIGNED BY:

APPROVED BY :-
A.M.

ARCHITECTURAL CONSULTANT :-
ARCHOPOLIS
17/13, BAINABGHATA ROAD, KOLKATA-700047
CONTACT: +91-9674590982; 9830504051
archopolis@gmail.com

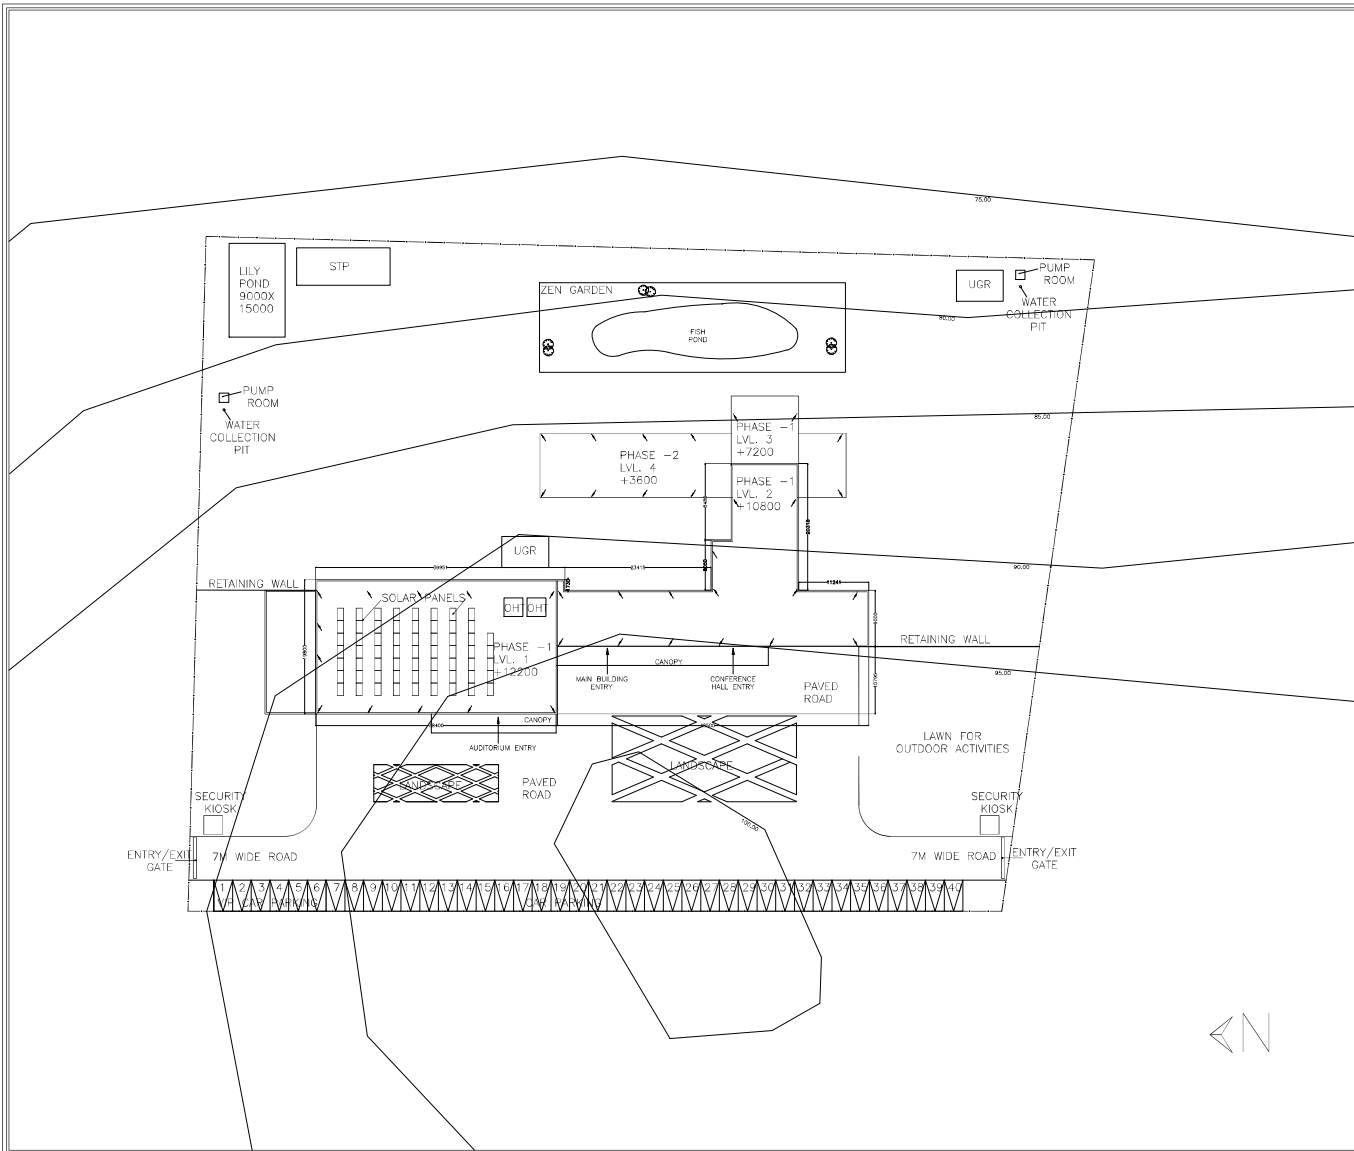

PROJECT TITLE :-
PROPOSED CONVENTION CENTER AT JONGLAPARA LOCALITY AT RESUBELPARA, NORTH GARO HILLS, MEGHALAYA-PHASE 2

CLIENT:
MEGHALAYA AGE LIMITED


FOR APPROVAL	RO		

DRAWING TITLE **MASTER PLAN**

DRAWING NO. :- **AR24/MAL/C8/ROM/AR-01** SHEET NO. **AR-01**

SCALE: NTS	DATE: 23.09.24	REVISION NO. -00
DRAWN BY:	DESIGNED BY:	APPROVED BY: A.M.

ARCHITECTURAL CONSULTANT :-
ARCHOPOLIS
17/13, BAINABGHATA ROAD, KOLKATA-700047
CONTACT: +91-9674590982; 9830504051
archopolis@gmail.com

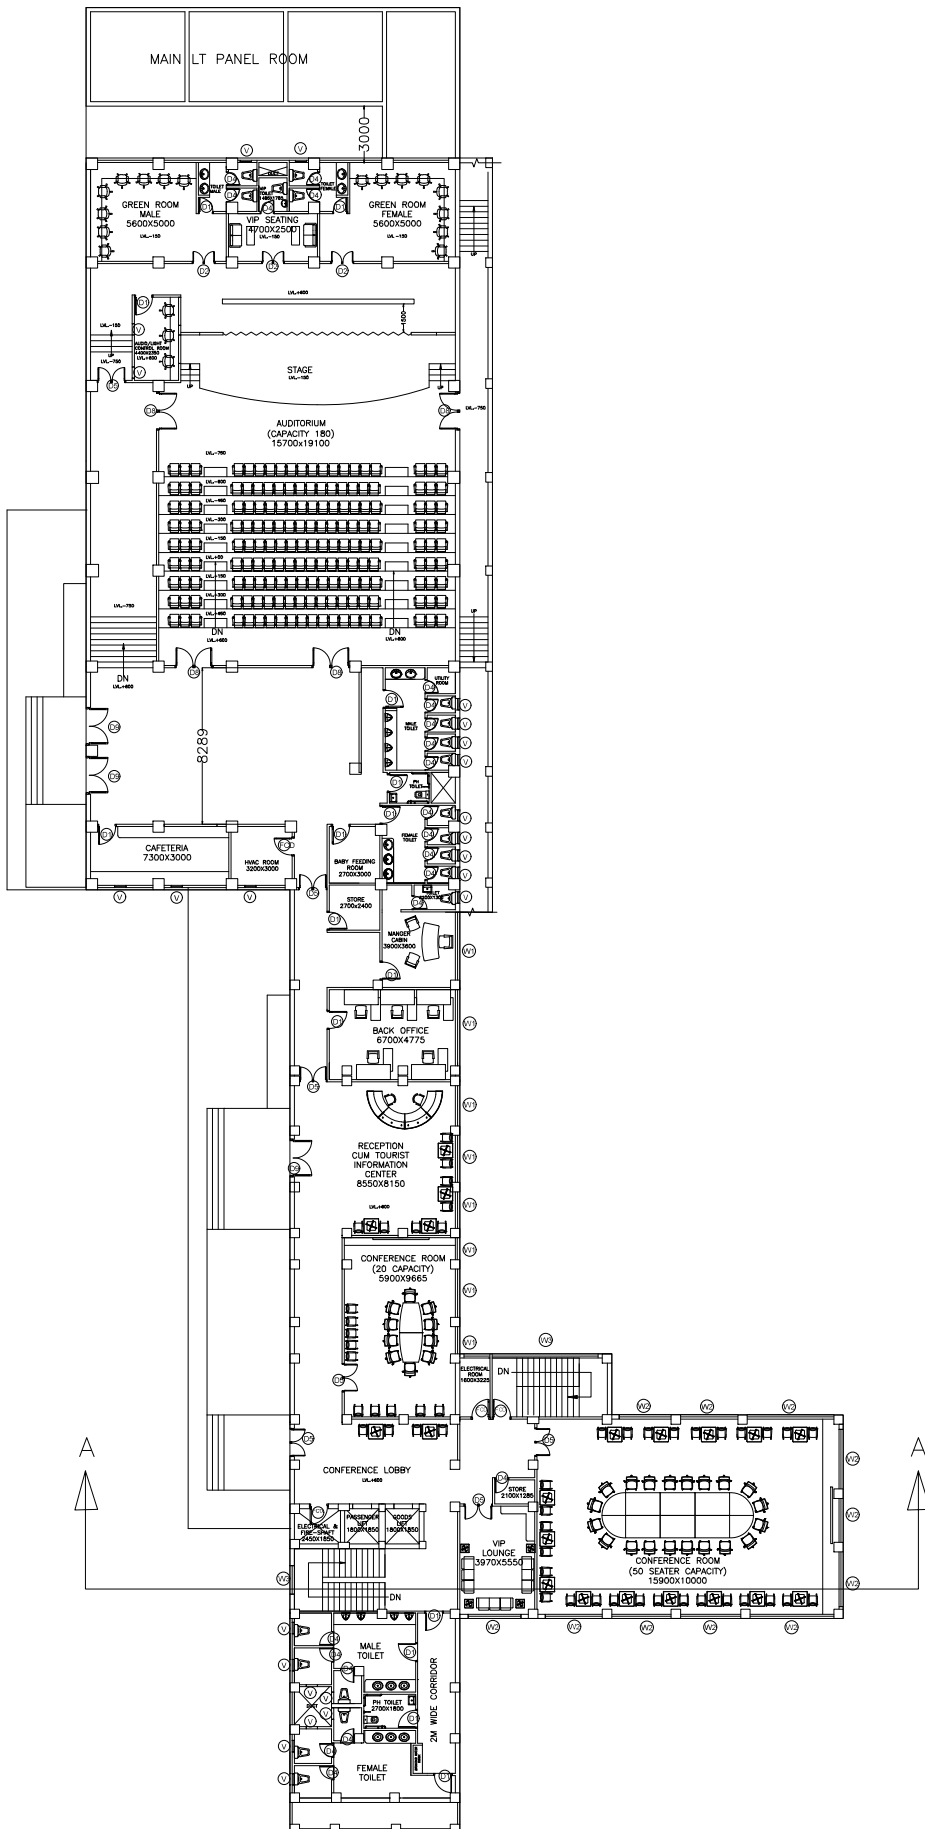

LVL.1 FLOOR PLAN
TOTAL AREA-1485.48 SQ.M.

SL. NO.	NAME	SIZE	SILL LVL.	UNTL. LVL.	TYPES.
1.	D1	1000X2100	00	2100	FLASH
2.	D2	1200X2100	00	2100	DOUBLE FLANGE FLASH
3.	D3	750X2100	00	2100	WOODEN FRAME SMOCKED TOUGHENED GLASS
4.	D4	750X2100	00	2100	PVC
5.	D5	1500X2100	00	2100	DOUBLE FLANGE FLASH
6.	D6	1000X2100	00	2100	DOUBLE FLANGE FLASH
7.	D7	1000X2100	00	2100	DOUBLE SWING FLASH
8.	D8	2000X2100	00	2100	DOUBLE FLANGE FLASH
9.	D9	2000X2100	00	2100	DOUBLE SWING TOUGHENED GLASS
10.	FCD	1000X2100	00	2100	FIRE RESISTANCE DOOR
11.	W1	3000 X (500) AS PER WALL LENGTH	150	3000	FIXED GLASS UPTO 750 MM LOUVERED GLASS WINDOW UPTO 3000MM
12.	W2	AS PER WALL LENGTH X WIDTH	150	3000	FIXED GLASS
13.	W3	900+1200+900 X AS WALL LENGTH	150	3000	2 SIDE FIXED GLASS UPTO 900 MM & GLASS WINDOW UPTO 1200 MM
14.	W4	900+1200+900 X 3400	150	3000	2 SIDE FIXED GLASS UPTO 900 MM & GLASS WINDOW UPTO 1200 MM
15.	V	600X750	1350	2100	TOILET VENTILATOR
16.	V1	900+1200+900 X 600	150	3000	TOILET VENTILATOR

PROJECT TITLE :-

PROPOSED CONVENTION CENTER AT JONGLAPARA LOCALITY AT RESUBELPARA, NORTH GARO HILLS, MEGHALAYA- PHASE 1

CLIENT:

MEGHALAYA AGE LIMITED

FOR APPROVAL

RO			

DRAWING TITLE

LEVEL- 1_ FLOOR PLAN

DRAWING NO. :-

AR24/MAL/C8/ROM/AR-02

SHEET NO.

AR-02

SCALE:

NTS

DATE:

23.09.24

REVISION NO. -R0

DRAWN BY:

DESIGNED BY:


APPROVED BY :-
A.M.

ARCHITECTURAL CONSULTANT :-

ARCHOPOLIS
ARCHITECTURE • URBAN PLANNING • TRANSPORT PLANNING • LANDSCAPE

17/13, BAISNABGHATA ROAD, KOLKATA-700047

CONTACT: +91-9674590982; 9830504051
archopolis@gmail.com

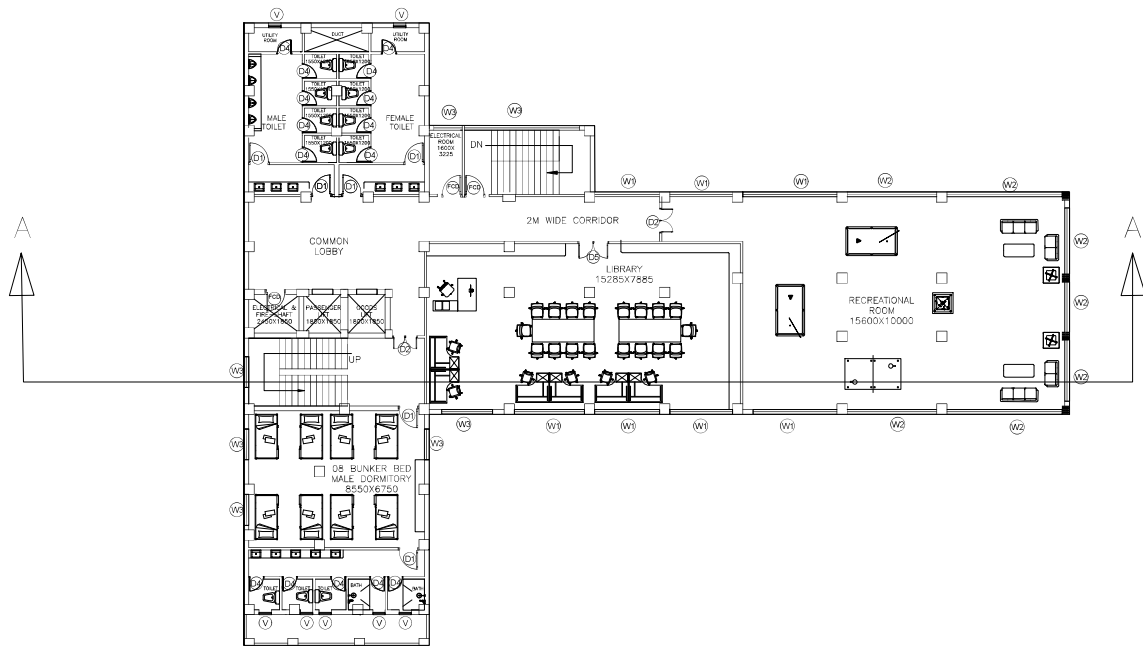

LVL.3 FLOOR PLAN
TOTAL AREA-634.4 SQ.M.

S. NO.	NAME	SIZE	ILL. LVL.	INTL. LVL.	TYPES.
1.	D1	1000X2100	00	2100	FLASH
2.	D2	1200X2100	00	2100	DOUBLE FLANGE FLASH
3.	D3	750X2100	00	2100	WOODEN FRAME SACKED TOUGHENED GLASS
4.	D4	750X2100	00	2100	PVC
5.	D5	1500X2100	00	2100	DOUBLE FLANGE FLASH
6.	D6	1000X2100	00	2100	DOUBLE FLANGE FLASH
7.	D7	1000X2100	00	2100	DOUBLE FLANGE FLASH
8.	D8	2000X2100	00	2100	DOUBLE FLANGE FLASH
9.	D9	2000X2100	00	2100	DOUBLE FLANGE FLASH
10.	F01	1000X2100	00	2100	TOUGHENED GLASS
11.	W1	3000 X 1500	150	3000	FRAMED GLASS UP TO 150 MM DOWN UP TO 300MM
12.	W2	AS PER WALL LENGTH X WIDTH	150	3000	FRAMED GLASS
13.	W3	900 X 1200 X 600	150	3000	3 SIDE FRAMED GLASS UP TO 150 MM & GLASS WINDOW UP TO 1200 MM
14.	W4	900 X 1200 X 600	150	3000	3 SIDE FRAMED GLASS UP TO 150 MM & GLASS WINDOW UP TO 1200 MM
15.	V	400X750	1350	2100	TOILET VENTILATOR
16.	V1	900 X 1200 X 600	150	3000	TOILET VENTILATOR

PROJECT TITLE :-
PROPOSED CONVENTION CENTER AT JONGLAPARA LOCALITY AT RESUBELPARA, NORTH GARO HILLS, MEGHALAYA- PHASE I

CLIENT:
MEGHALAYA AGE LIMITED

FOR APPROVAL	RO		


DRAWING TITLE **LEVEL-3_FLOOR PLAN**

DRAWING NO. :- **AR24/MAL/C8/ROM/AR-04** SHEET NO. **AR-04**

SCALE: **NTS** DATE: **23.09.24** REMISION NO. **40**

DRAWN BY: **DESIGNED BY: APPROVED BY: A.M.**

ARCHITECTURAL CONSULTANT :-
ARCHOPOLIS
17/13, BAINABGHATA ROAD, KOLKATA-700047
CONTACT: +91-9674590982; 9830504051
archopolis@gmail.com

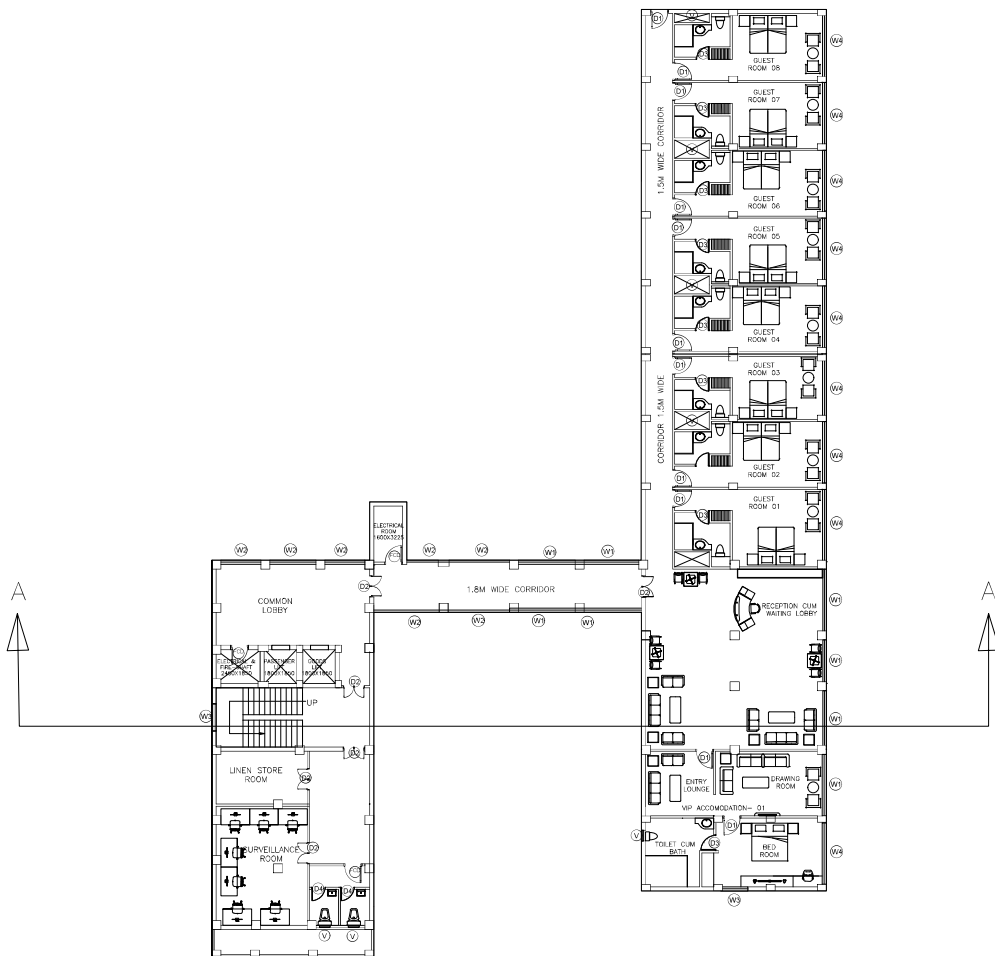

LVL.4 FLOOR PLAN
TOTAL AREA-752.2 SQ.M.

SL. NO.	NAME	SIZE	REL. LVL.	UNIT. LVL.	TYPES
1.	D1	1000X2100	00	2100	FLASH
2.	D2	1200X2100	00	2100	DOUBLE FLANGE FLASH
3.	D3	1400X2100	00	2100	WOODEN FRAME BRANCHED TIGHTENED GLASS
4.	D4	1600X2100	00	2100	PVC
5.	D5	1800X2100	00	2100	DOUBLE FLANGE FLASH
6.	D6	1000X2100	00	2100	DOUBLE FLANGE FLASH
7.	D7	1000X2100	00	2100	DOUBLE SHIMS GLASS
8.	D8	2000X2100	00	2100	DOUBLE FLANGE FLASH
9.	D9	2000X2100	00	2100	DOUBLE SHIMS TOUGHENED GLASS
10.	FCR	1000X2100	00	2100	FIRE RESISTANCE DOOR
11.	W1	2000 X 1600 AS PER WALL LENGTH	150	3000	FRONT GLASS UPTO 750 MM LAUNDRY GLASS WINDOW UPTO 3000MM
12.	W2	AS PER WALL LENGTH X WIDTH	150	3000	FRONT GLASS
13.	W3	900 X 1200-600 X 60 WALL MOUNTED	150	3000	1 SIDE FRONT GLASS UPTO 600 MM X GLASS WINDOW UPTO 1200 MM
14.	W4	600 X 1200-600 X 3400	150	3000	1 SIDE FRONT GLASS UPTO 600 MM X GLASS WINDOW UPTO 1200 MM
15.	V	600X760	1350	2100	TOILET VENTILATOR
16.	V1	800 X 1200-600 X 1600	150	3000	TOILET VENTILATOR

PROJECT TITLE :-
PROPOSED CONVENTION CENTER AT JONGLAPARA LOCALITY AT RESUBELPARA, NORTH GARO HILLS, MEGHALAYA- PHASE 2

CLIENT:
MEGHALAYA AGE LIMITED

FOR APPROVAL	RO		

DRAWING TITLE
LEVEL-4_FLOOR PLAN

DRAWING NO. :-
AR24/MAL/C8/ROM/AR-05

SCALE: NTS DATE: 23.09.24

DRAWN BY: DESIGNED BY: APPROVED BY: A.M.

REVISION NO. -00


ARCHITECTURAL CONSULTANT :-

ARCHOPOLIS


17/13, BAINNABGHATA ROAD, KOLKATA-700047

CONTACT: -91-9674590962; 9830504051

archopolis@gmail.com

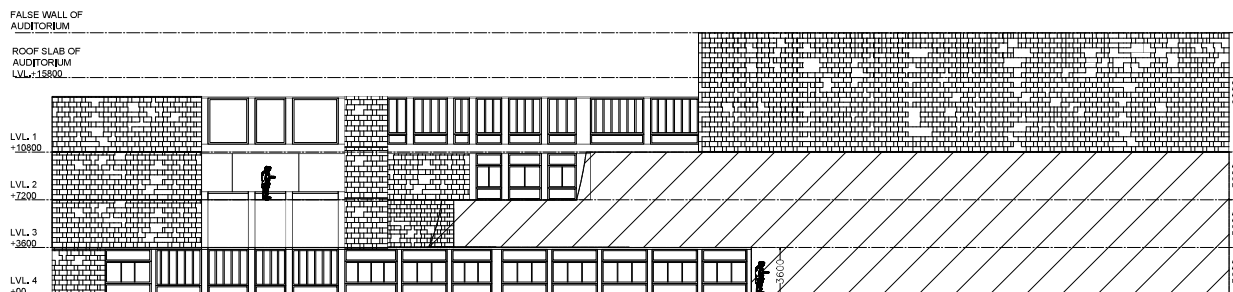

MAIN BUILDING BLOCK _ FRONT ELEVATION

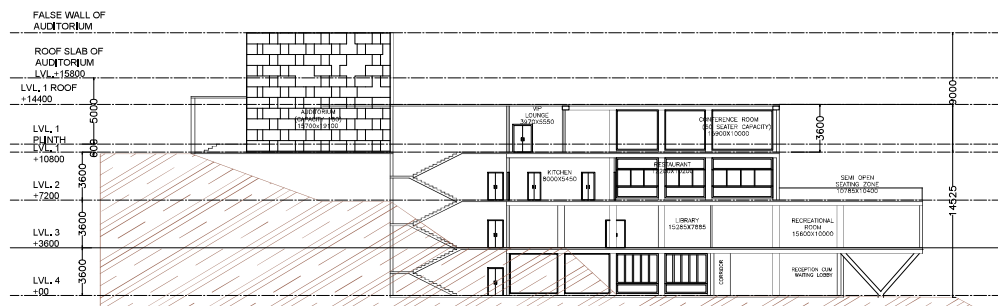

MAIN BUILDING BLOCK SECTION -AA'

SL NO.	NAME	SIZE	SHL LVSL	HTLVSL	TYPES
1.	D1	1000X210	0	2100	FLASH
2.	D2	1000X210	0	2100	DOUBLE FLANGE LUGS
3.	D3	700X210	0	2100	DOUBLE FLANGE LUGS 1000X210 FLANGE 300X40 1000X210 FLANGE 300X40
4.	D4	700X210	0	2100	PVC
5.	D5	1000X210	0	2100	DOUBLE FLANGE
6.	D6	1000X210	0	2100	DOUBLE FLANGE
7.	D7	1000X210	0	2100	DOUBLE FLANGE
8.	D8	1000X210	0	2100	DOUBLE FLANGE
9.	D9	2000X210	0	2100	DOUBLE FLANGE
10.	FCO	1000X210	0	2100	DOUBLE FLANGE
11.	WD	300 X 400 X 20	150	3000	REINFORCING LUGS 1000X210 FLANGE 300X40 1000X210 FLANGE 300X40 1000X210 FLANGE 300X40
12.	WZ	300 X 400 X 20	150	3000	REINFORCING LUGS 1000X210 FLANGE 300X40 1000X210 FLANGE 300X40 1000X210 FLANGE 300X40
13.	WS	1000X1200X 40	150	3000	REINFORCING LUGS 1000X210 FLANGE 300X40 1000X210 FLANGE 300X40 1000X210 FLANGE 300X40
14.	WM	1000X1200X 40	150	3000	REINFORCING LUGS 1000X210 FLANGE 300X40 1000X210 FLANGE 300X40 1000X210 FLANGE 300X40
15.	V	1000X1200X 40	150	3000	REINFORCING LUGS 1000X210 FLANGE 300X40 1000X210 FLANGE 300X40 1000X210 FLANGE 300X40
16.	V	1000X1200X 40	150	3000	REINFORCING LUGS 1000X210 FLANGE 300X40 1000X210 FLANGE 300X40 1000X210 FLANGE 300X40

PROJECT TITLE :-

**PROPOSED CONVENTION CENTER AT
JONGLAPARA LOCALITY AT
RESUBELPARA, NORTH GARO HILLS,
MEGHALAYA- PHASE 2**

CLIENT:

MEGHALAYA AGE LIMITED

[illegible]

DRAWING TITLE	MAIN BUILDING BLOCK _FRONT ELEVATION & SECTION
---------------	--

DRAWING NO. :-
AR24/MAL/C8/ROM/AR-06

SHEET NO.

AR-06


SCALE: NTS	DATE: 25.09.24	REVISION NO. 00
DRAWN BY:	DESIGNED BY:	APPROVED BY A.M.

ARCHITECTURAL CONSULTANT :


ARCHOPOLIS

17/13, BAISNABGHATA ROAD, KOLKATA-700047

CONTACT: +91-9674590982; 9830504051
archopolis@gmail.com

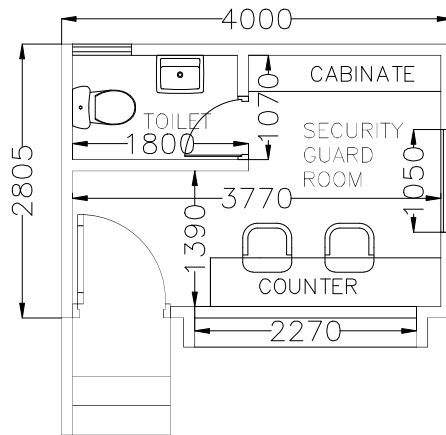

SECURITY KIOSK
FLOOR PLAN

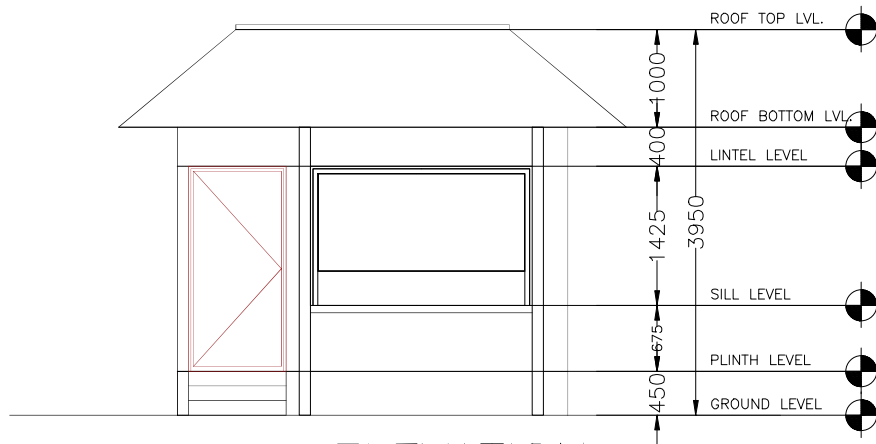

FRONT ELEVATION

PROJECT TITLE :-

PROPOSED CONVENTION CENTER AT
JONGLAPARA LOCALITY AT
RESUBELPARA, NORTH GARO HILLS,
MEGHALAYA- PHASE I

CLIENT:

MEGHALAYA AGE LIMITED

FOR APPROVAL

DRAWING TITLE

SECURITY KIOSK

DRAWING NO. :-

AR24/MAL/C8/ROM/AR-07

SHEET NO.

AR-07

SCALE:

NTS

DATE:

23.09.24

REVISION NO. :-0

DRAWN BY:

DESIGNED BY:

APPROVED BY :-

A.M.


ARCHITECTURAL CONSULTANT :-

ARCHOPOLIS


17/13, BAINABGHATA ROAD, KOLKATA-700047

CONTACT: +91-9674590982; 9830504051


archopolis@gmail.com

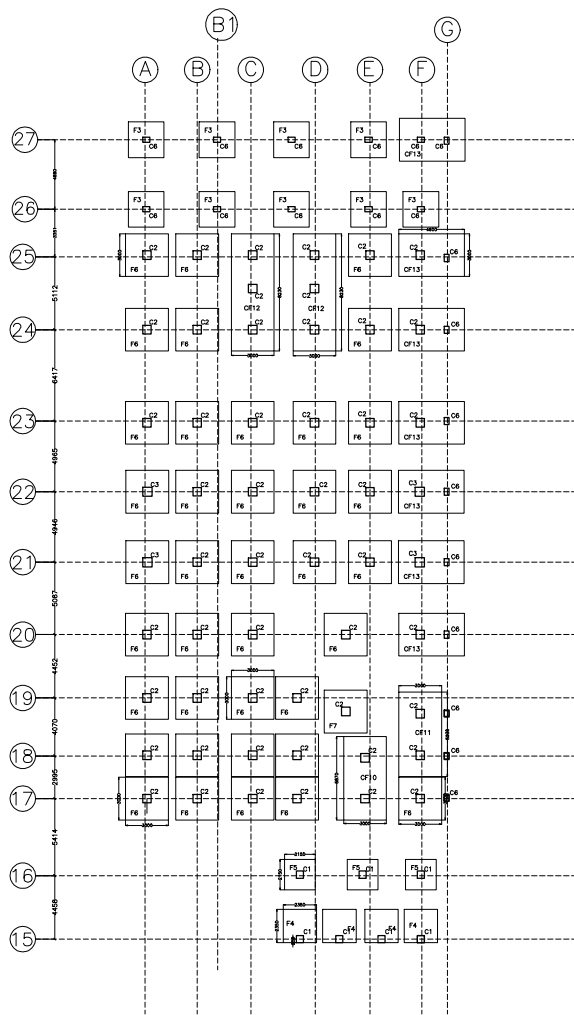

FOUNDATION LAYOUT PLAN
B.O.F AT LEVEL -2.0 M FROM
E.G.L

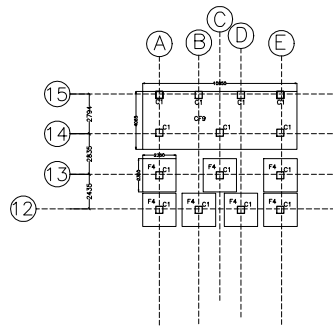

FOUNDATION LAYOUT PLAN
B.O.F AT LEVEL -5.0M FROM
E.G.L

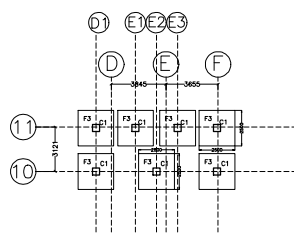

FOUNDATION LAYOUT AT -8.6 M
DEPTH

PROJECT TITLE :-
PROPOSED CONVENTION CENTER AT
JONGLPARA LOCALITY AT
RESUBELPARA, NORTH GARO HILLS,
MEGHALAYA-PHASE 2

CLIENT:
MEGHALAYA AGE LIMITED

FOR APPROVAL	RO		


DRAWING TITLE
FOUNDATION LAYOUT
PHASE -1

DRAWING NO. :-
AR24/MAL/C8/ROM/ST-01

SCALE: NTS DATE: 25.09.24

DRAWN BY: DESIGNED BY: APPROVED BY: A.M.

ARCHITECTURAL CONSULTANT :-
ARCHOPOLIS
17/13, BAISNABGHATA ROAD, KOLKATA-700047
CONTACT: +91- 9674590962; 9830504051
archopolis@gmail.com

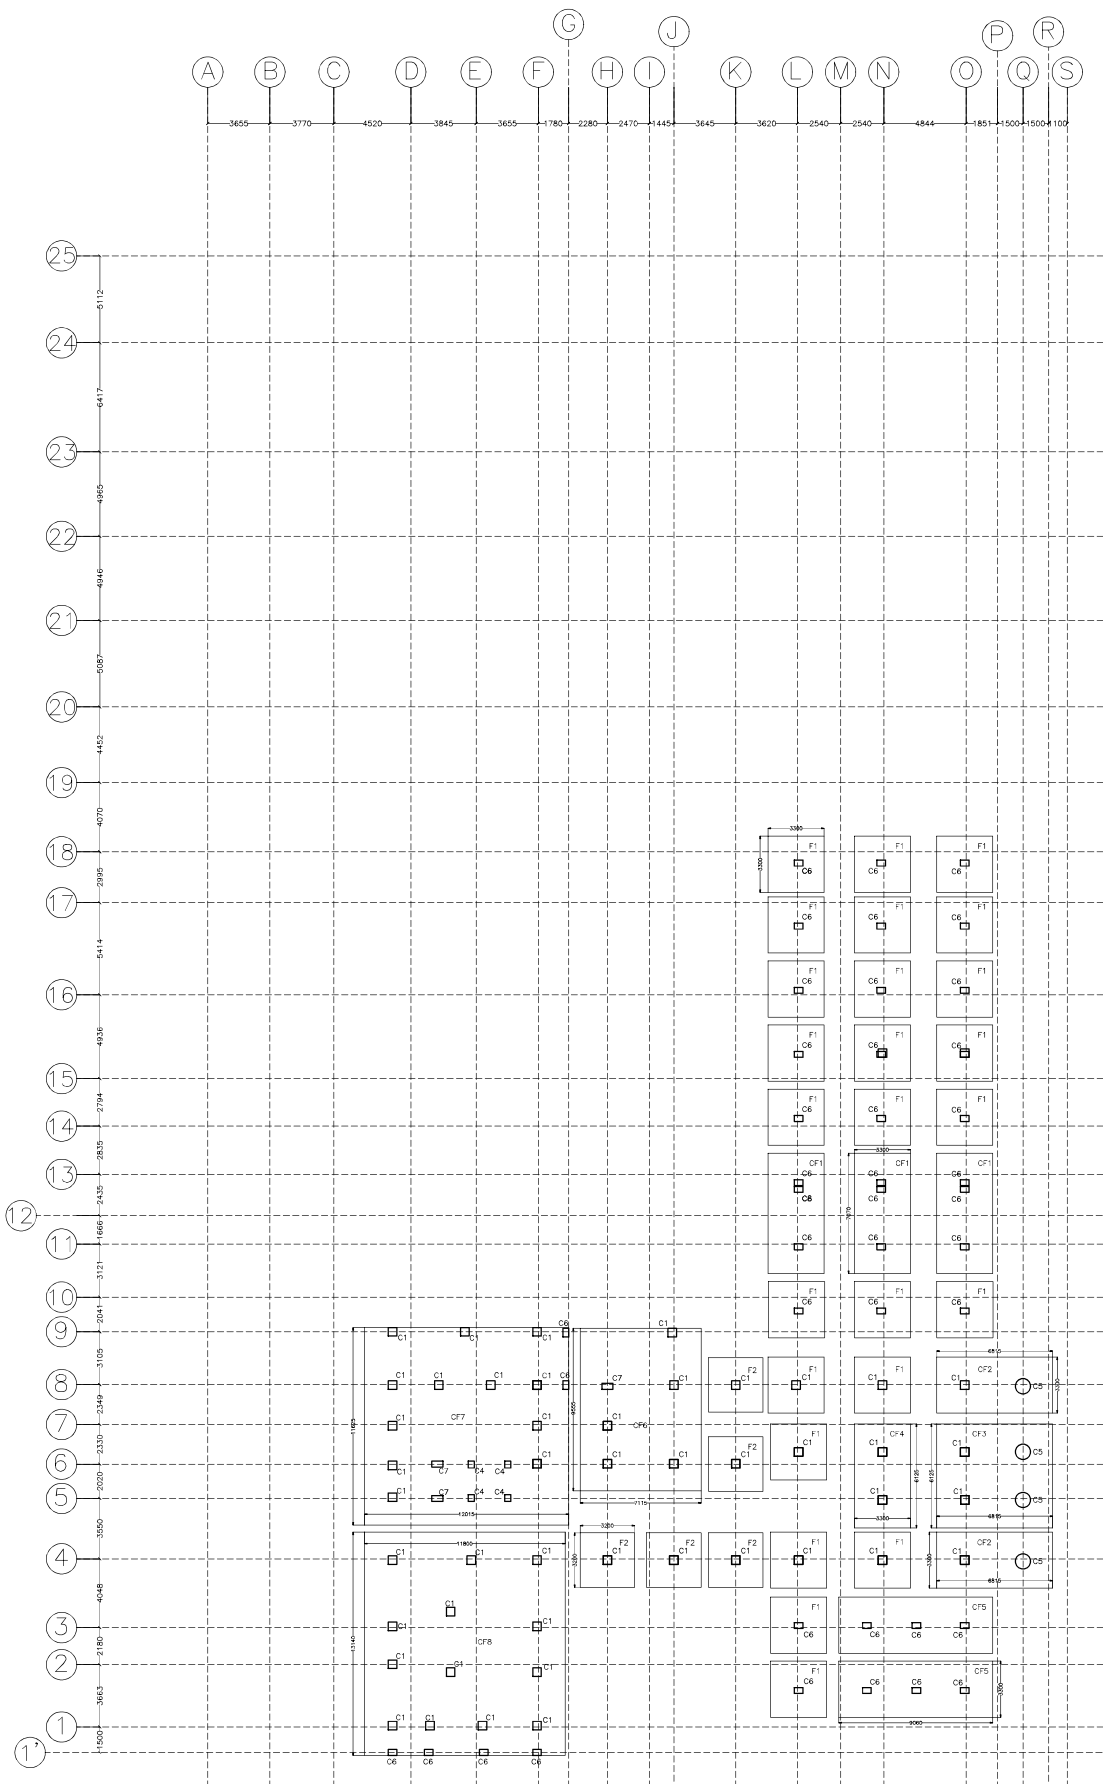

FOUNDATION LAYOUT PLAN
B.O.F AT LEVEL -12.2M FROM
E.G.L

PROJECT TITLE :-
**PROPOSED CONVENTION CENTER
AT JONGLAPARA LOCALITY AT
RESUBELPARA, NORTH GARO
HILLS, MEGHALAYA- PHASE 2**

CLIENT:
Meghalaya Age Limited

FOR APPROVAL	RO		

DRAWING TITLE
FOUNDATION LAYOUT
PHASE -2

DRAWING NO. :-
AR24/MAL/C8/ROM/ST-02 SHEET NO.
ST-2

SCALE: **NTS** DATE: **24.08.24** REVISION NO. -R0

DRAWN BY: DESIGNED BY: APPROVED BY :-
A.M.


REF NO:-

ARCHITECTURAL CONSULTANT :-

ARCHOPOLIS
ARCHITECTURE • URBAN PLANNING • TRANSPORT PLANNING • LANDSCAPE




17/13, BAISNABGHATA ROAD, KOLKATA-700047

CONTACT: +91- 9674590982; 9830504051
archopolis@gmail.com

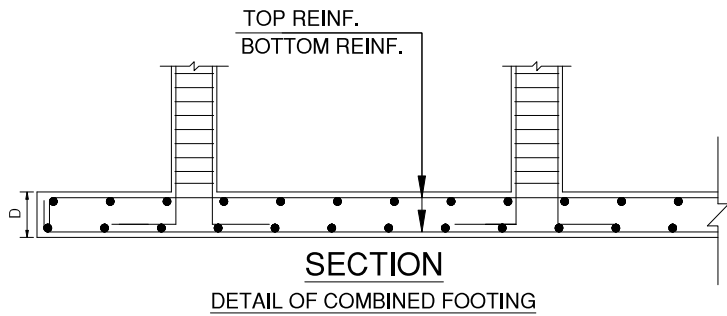

FOOTING SCHEDULE (M25:Fe500)

FOOTING NUMBERS	FOOTING TYPE	FOOTING DIMENSION			FOOTING REINFORCEMENT			
		L	B	D	BOTTOM		TOP	
					ALONG B	ALONG L	ALONG B	ALONG L
F1	Pad	3300	3300	600	T12@125 C/C	T12@125 C/C	T12@125 C/C	T12@125 C/C
F2	Pad	3200	3200	600	T12@150 C/C	T12@150 C/C	T12@150 C/C	T12@150 C/C
F3	Pad	2500	2500	450	T12@125 C/C	T12@125 C/C	T12@125 C/C	T12@125 C/C
F4	Pad	2350	2350	450	T12@125 C/C	T12@125 C/C	T12@125 C/C	T12@125 C/C
F5	Pad	2150	2150	450	T12@125 C/C	T12@125 C/C	T12@125 C/C	T12@125 C/C
F6	Pad	3000	3000	500	T12@150 C/C	T12@150 C/C	T12@150 C/C	T12@150 C/C
CF1	Pad	7070	3300	600	T12@125 C/C	T12@125 C/C	T12@125 C/C	T12@125 C/C
CF2	Pad	6815	3300	600	T12@125 C/C	T12@125 C/C	T12@125 C/C	T12@125 C/C
CF3	Pad	6815	6125	600	T12@125 C/C	T12@125 C/C	T12@125 C/C	T12@125 C/C
CF4	Pad	6125	3300	600	T12@125 C/C	T12@125 C/C	T12@125 C/C	T12@125 C/C
CF5	Pad	9060	3300	600	T12@125 C/C	T12@125 C/C	T12@125 C/C	T12@125 C/C
CF6	Pad	9555	7115	650	T12@125 C/C	T12@125 C/C	T12@125 C/C	T12@125 C/C
CF7	Pad	12015	11625	650	T12@125 C/C	T12@125 C/C	T12@125 C/C	T12@125 C/C
CF8	Pad	13140	11800	650	T12@125 C/C	T12@125 C/C	T12@125 C/C	T12@125 C/C
CF9	Pad	10850	4065	600	T12@125 C/C	T12@125 C/C	T12@125 C/C	T12@125 C/C
CF10	Pad	5870	3000	500	T12@125 C/C	T12@125 C/C	T12@125 C/C	T12@125 C/C
CF11	Pad	5930	3000	500	T12@125 C/C	T12@125 C/C	T12@125 C/C	T12@125 C/C
CF12	Pad	8230	3000	500	T12@125 C/C	T12@125 C/C	T12@125 C/C	T12@125 C/C
CF13	Pad	4600	3000	500	T12@125 C/C	T12@125 C/C	T12@125 C/C	T12@125 C/C

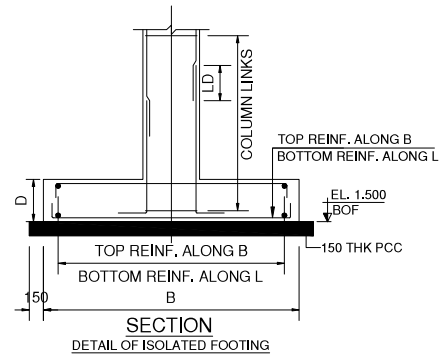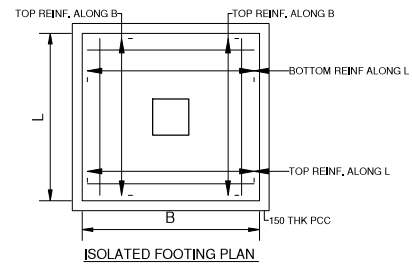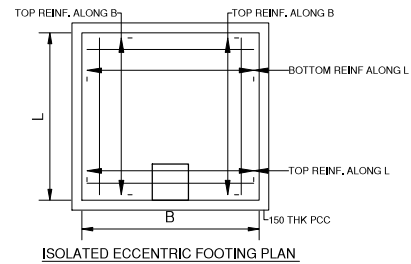

PROJECT TITLE :-
**PROPOSED CONVENTION CENTER
AT JONGLAPARA LOCALITY AT
RESUBELPARA, NORTH GARO
HILLS, MEGHALAYA- PHASE 2**

CLIENT:
Meghalaya Age Limited

FOR APPROVAL	RO		


DRAWING TITLE
**FOOTING SCHEDULE &
DETAILS**

DRAWING NO. :- **AR24/MAL/C8/ROM/ST-03** SHEET NO. **3**

SCALE: NTS	DATE: 24.08.24	REVISION NO. :- 00
DRAWN BY:	DESIGNED BY:	APPROVED BY :- A.J.M.

REF NO:-

ARCHITECTURAL CONSULTANT :-
ARCHOPOLIS
17/13, BAISNABGHATA ROAD, KOLKATA-700047
CONTACT:- +91- 9674590982; 9830504051
archopolis@gmail.com

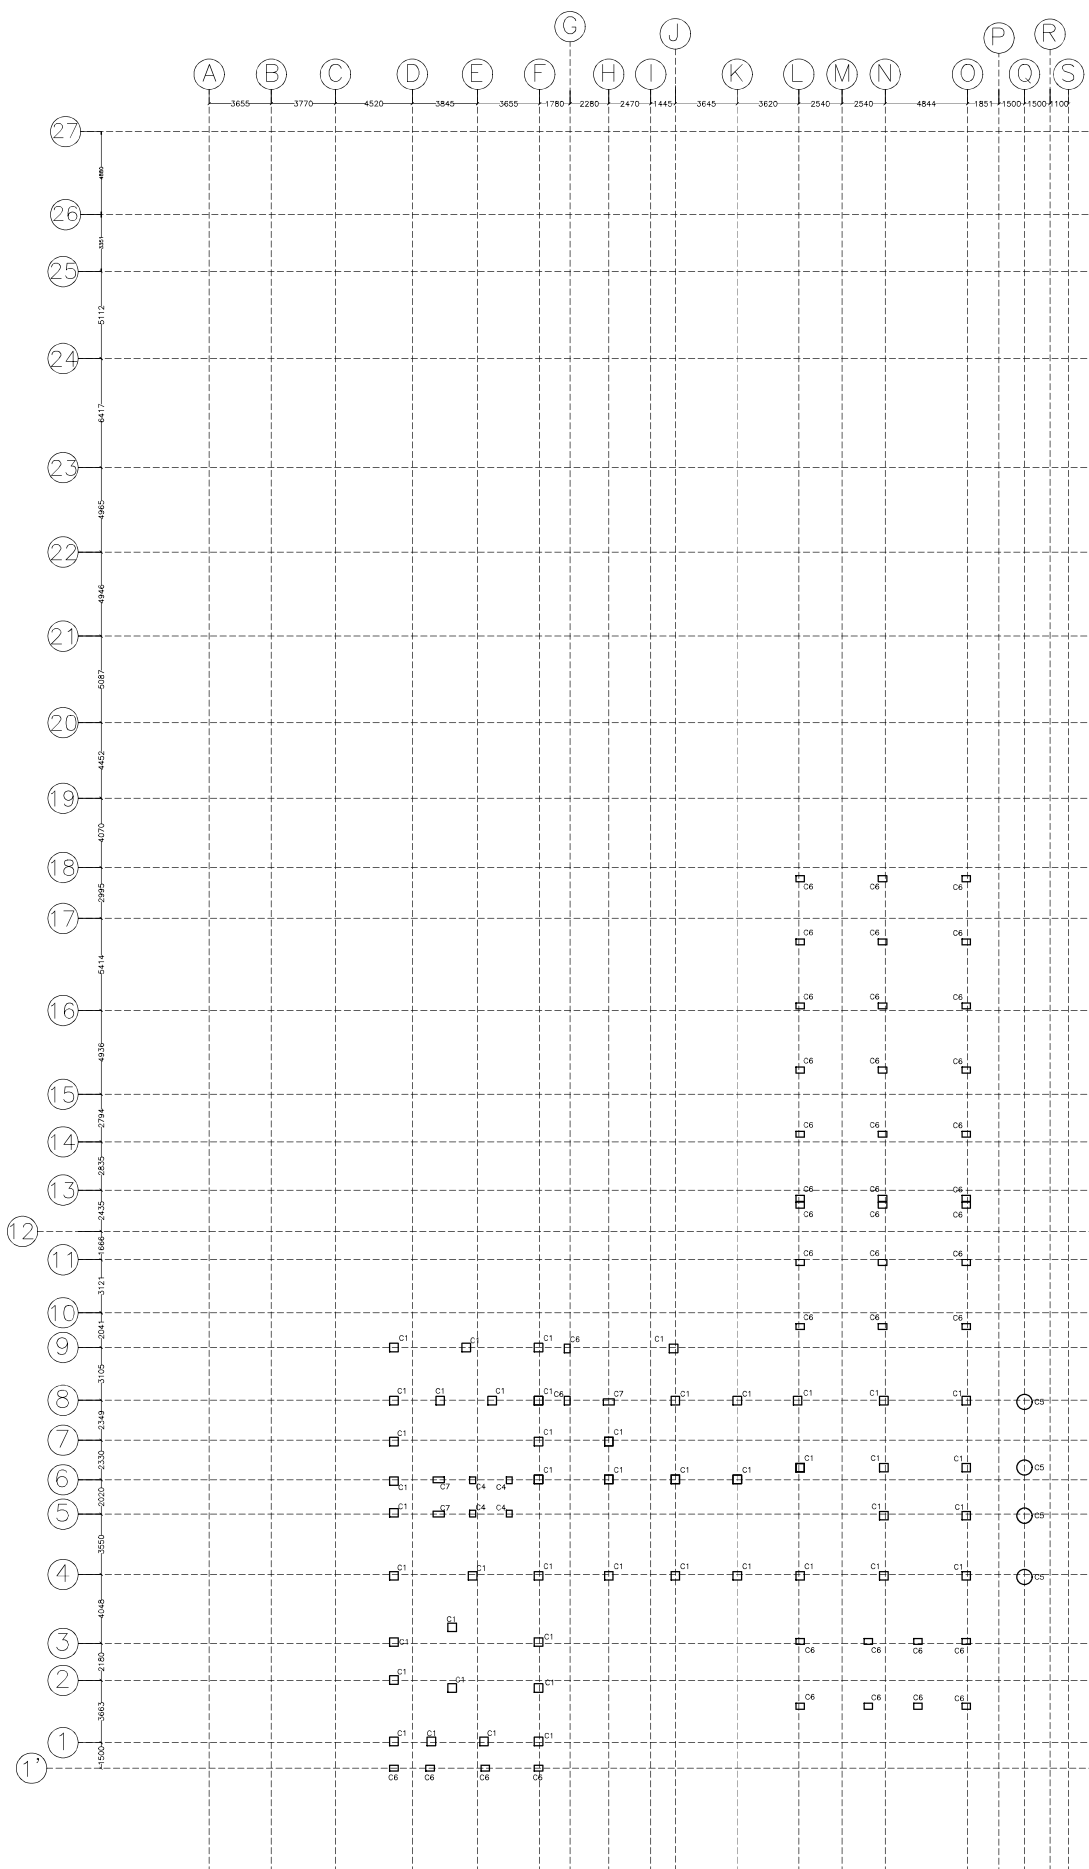

PROJECT TITLE :-
**PROPOSED CONVENTION CENTER
 AT JONGLAPARA LOCALITY AT
 RESUBELPARA, NORTH GARO
 HILLS, MEGHALAYA- PHASE 2**

CLIENT:
Meghalaya Age Limited

FOR APPROVAL	RO		

DRAWING TITLE
 COLUMN AT LEVEL -10.2M


DRAWING NO. :-
AR24/MAL/C8/ROM/ST-04 SHEET NO.
4

SCALE: **NTS** DATE: **24.08.24** REVISION NO. -R0
 DRAWN BY: DESIGNED BY: APPROVED BY :-
 A.M.

REF NO:- **AR24/MAL/C9/CH_2/AR-01**

ARCHITECTURAL CONSULTANT :-
ARCHOPOLIS
 ARCHITECTURE • INTERIORS • LANDSCAPE
 17/13, BAISNABGHATA ROAD, KOLKATA-700047
 CONTACT: +91- 9674590982; 9830504051
 archopolis@gmail.com

COLUMN AT LEVEL -10.2M

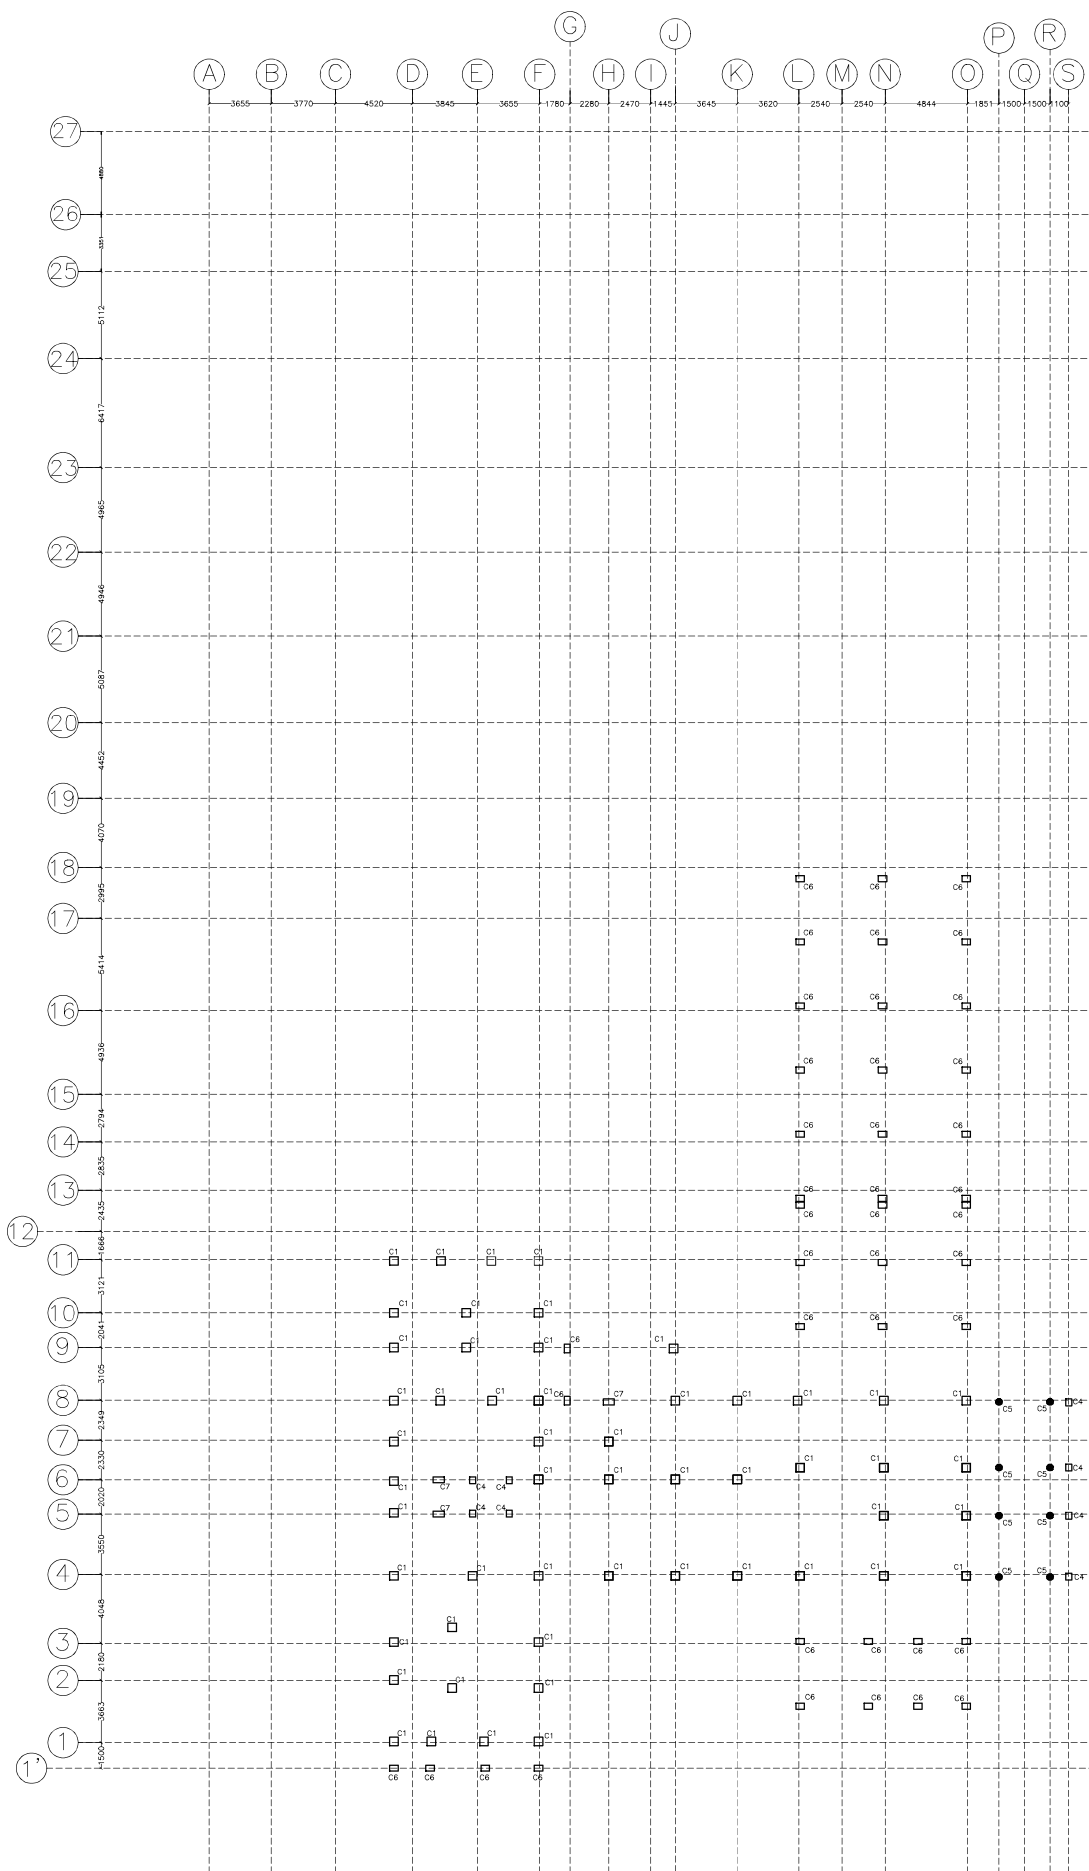

COLUMN AT LEVEL -6.6M

PROJECT TITLE :-
**PROPOSED CONVENTION CENTER
 AT JONGLAPARA LOCALITY AT
 RESUBELPARA, NORTH GARO
 HILLS, MEGHALAYA- PHASE 2**

CLIENT:
Meghalaya Age Limited

FOR APPROVAL	RO		

DRAWING TITLE
 COLUMN AT LEVEL -6.6M

DRAWING NO. :-
AR24/MAL/C8/ROM/ST-05 SHEET NO.
5

SCALE: **NTS** DATE: **24.08.24** REVISION NO. -R0

DRAWN BY: DESIGNED BY: APPROVED BY :-
 A.M.


REF NO:- **AR24/MAL/C9/CH_2/AR-01**

ARCHITECTURAL CONSULTANT :-

ARCHOPOLIS
 ARCHITECTURE • URBAN PLANNING • TRANSPORT PLANNING • LANDSCAPE

17/13, BAISNABGHATA ROAD, KOLKATA-700047

CONTACT: +91- 9674590982; 9830504051
 archopolis@gmail.com

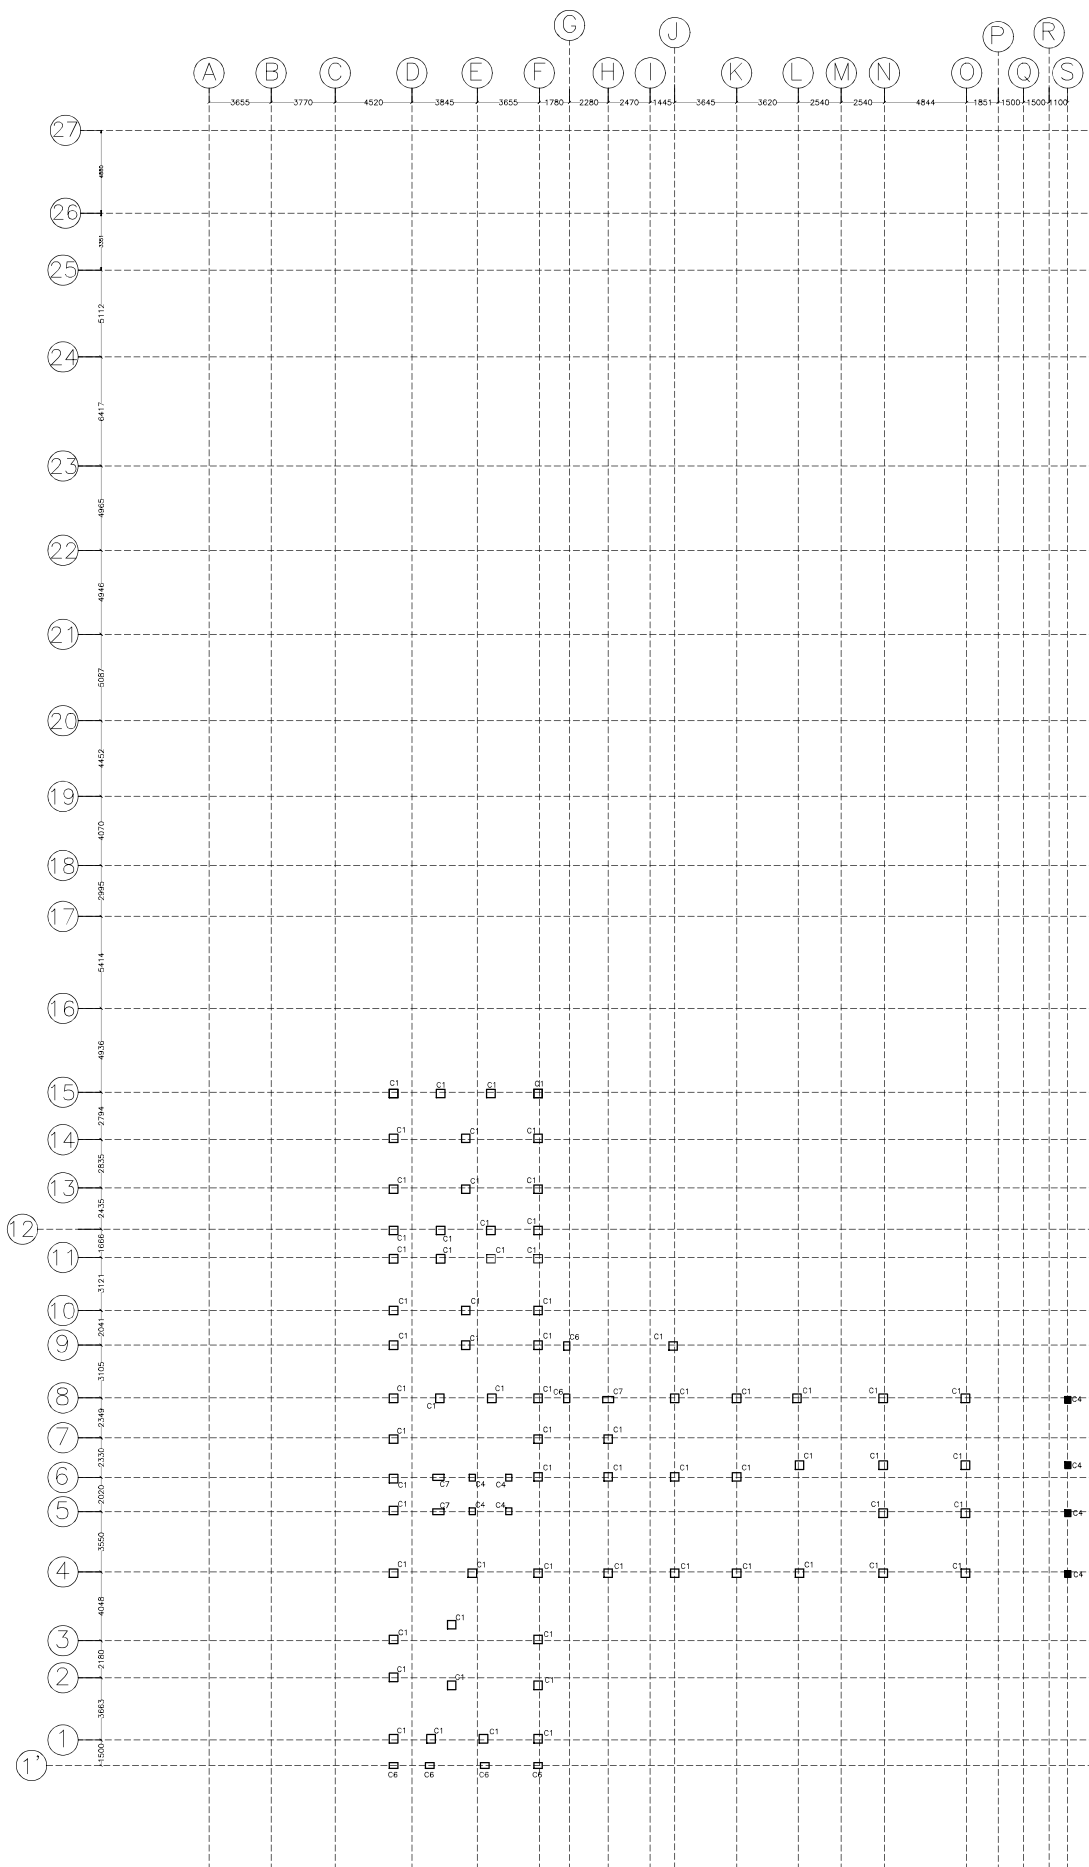

COLUMN LAYOUT AT LEVEL -3.0M

PROJECT TITLE :-
**PROPOSED CONVENTION CENTER
 AT JONGLAPARA LOCALITY AT
 RESUBELPARA, NORTH GARO
 HILLS, MEGHALAYA- PHASE 2**

CLIENT:
Meghalaya Age Limited

FOR APPROVAL	RO		

DRAWING TITLE
 COLUMN LAYOUT AT LEVEL
 -3.0M

DRAWING NO. :-
AR24/MAL/C8/ROM/ST-06 SHEET NO.
ST-6

SCALE: NTS	DATE: 24.08.24	REVISION NO. -RO
DRAWN BY:	DESIGNED BY:	APPROVED BY :- A.M.


REF NO:-

ARCHITECTURAL CONSULTANT :-

ARCHOPOLIS
 ARCHITECTURE • URBAN PLANNING • TRANSPORT PLANNING • LANDSCAPE

17/13, BAINABGHATA ROAD, KOLKATA-700047

CONTACT: +91- 9674590982; 9830504051
 archopolis@gmail.com

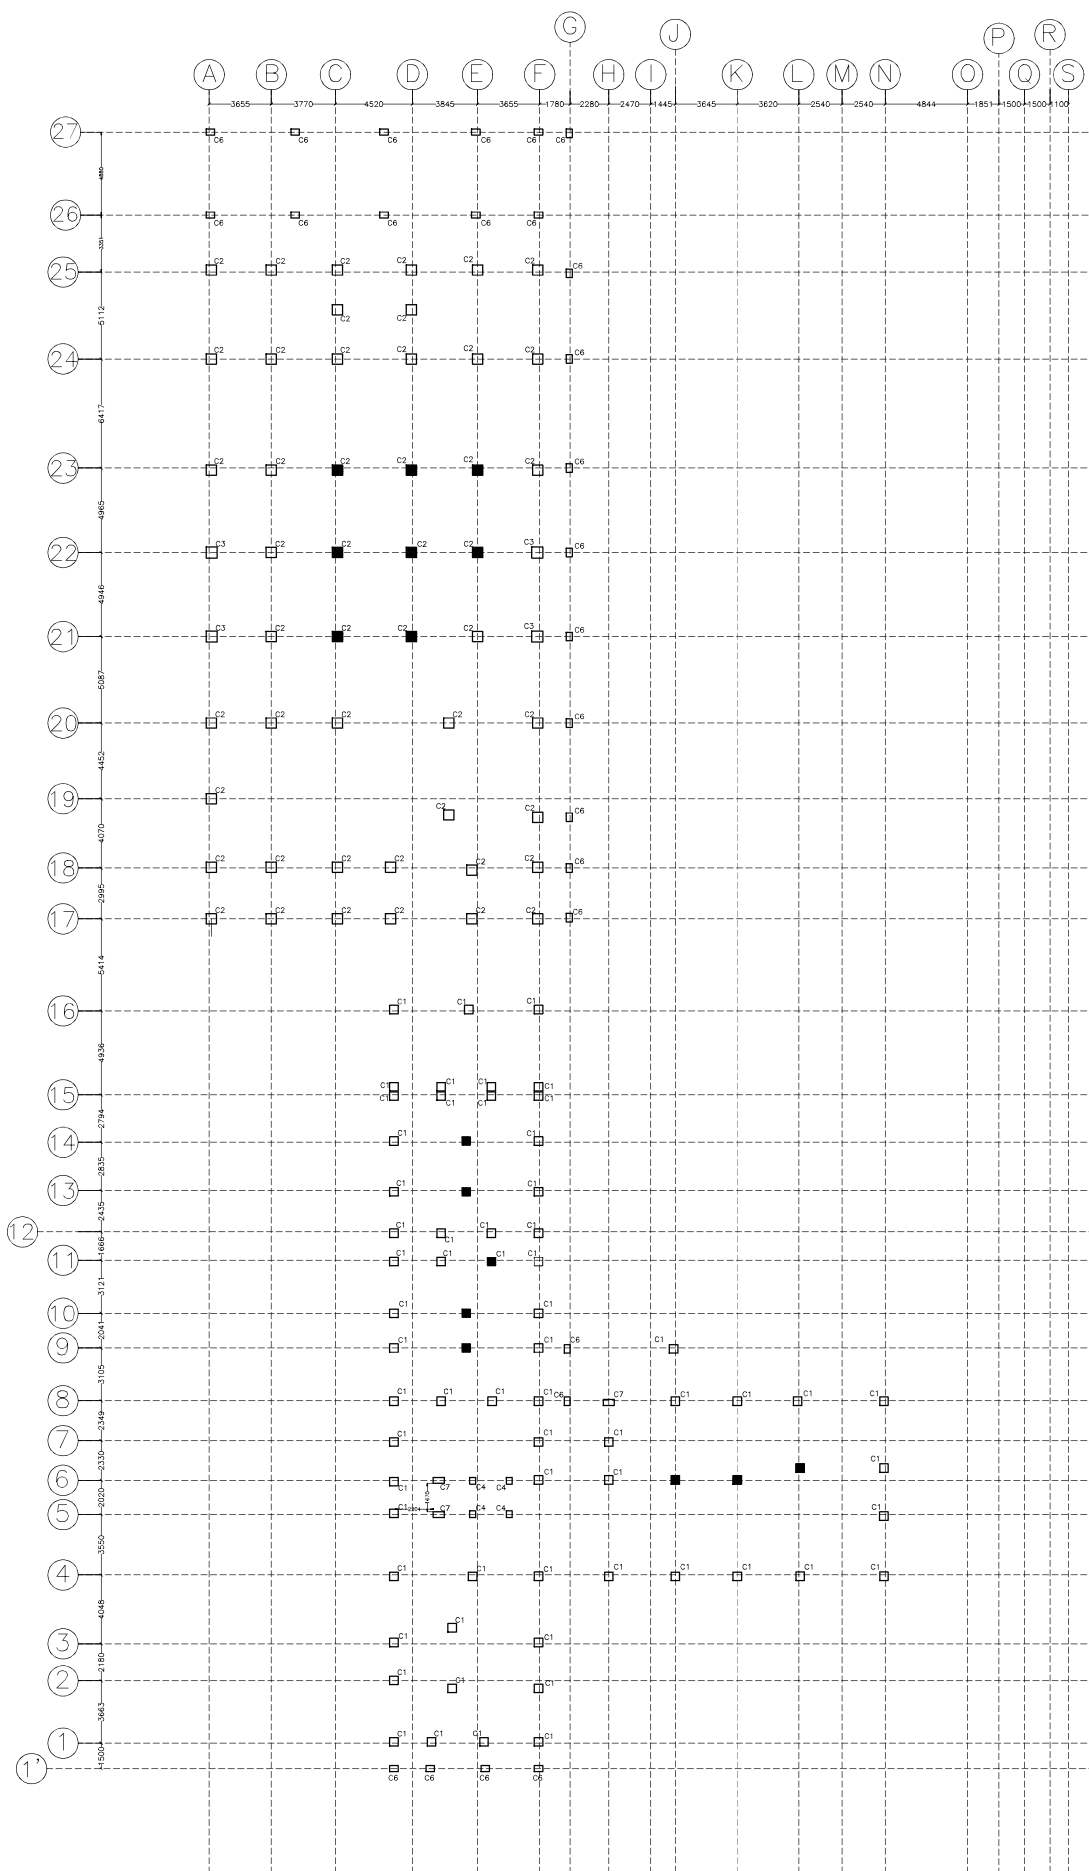

PROJECT TITLE :-
**PROPOSED CONVENTION CENTER
 AT JONGLAPARA LOCALITY AT
 RESUBELPARA, NORTH GARO
 HILLS, MEGHALAYA- PHASE 2**

CLIENT:
Meghalaya Age Limited

FOR APPROVAL	RO		

DRAWING TITLE
 COLUMN LEVEL +0.600M

DRAWING NO. :-
AR24/MAL/C8/ROM/ST-07

SHEET NO.
ST-7

SCALE: **NTS**

DATE: **24.08.24**

REVISION NO. -R0

DRAWN BY: **DESIGNED BY: APPROVED BY :-**
 A.M.


REF NO:-

ARCHITECTURAL CONSULTANT :-



17/13, BAINABGHATA ROAD, KOLKATA-700047

CONTACT: +91- 9674590982; 9830504051
 archopolis@gmail.com

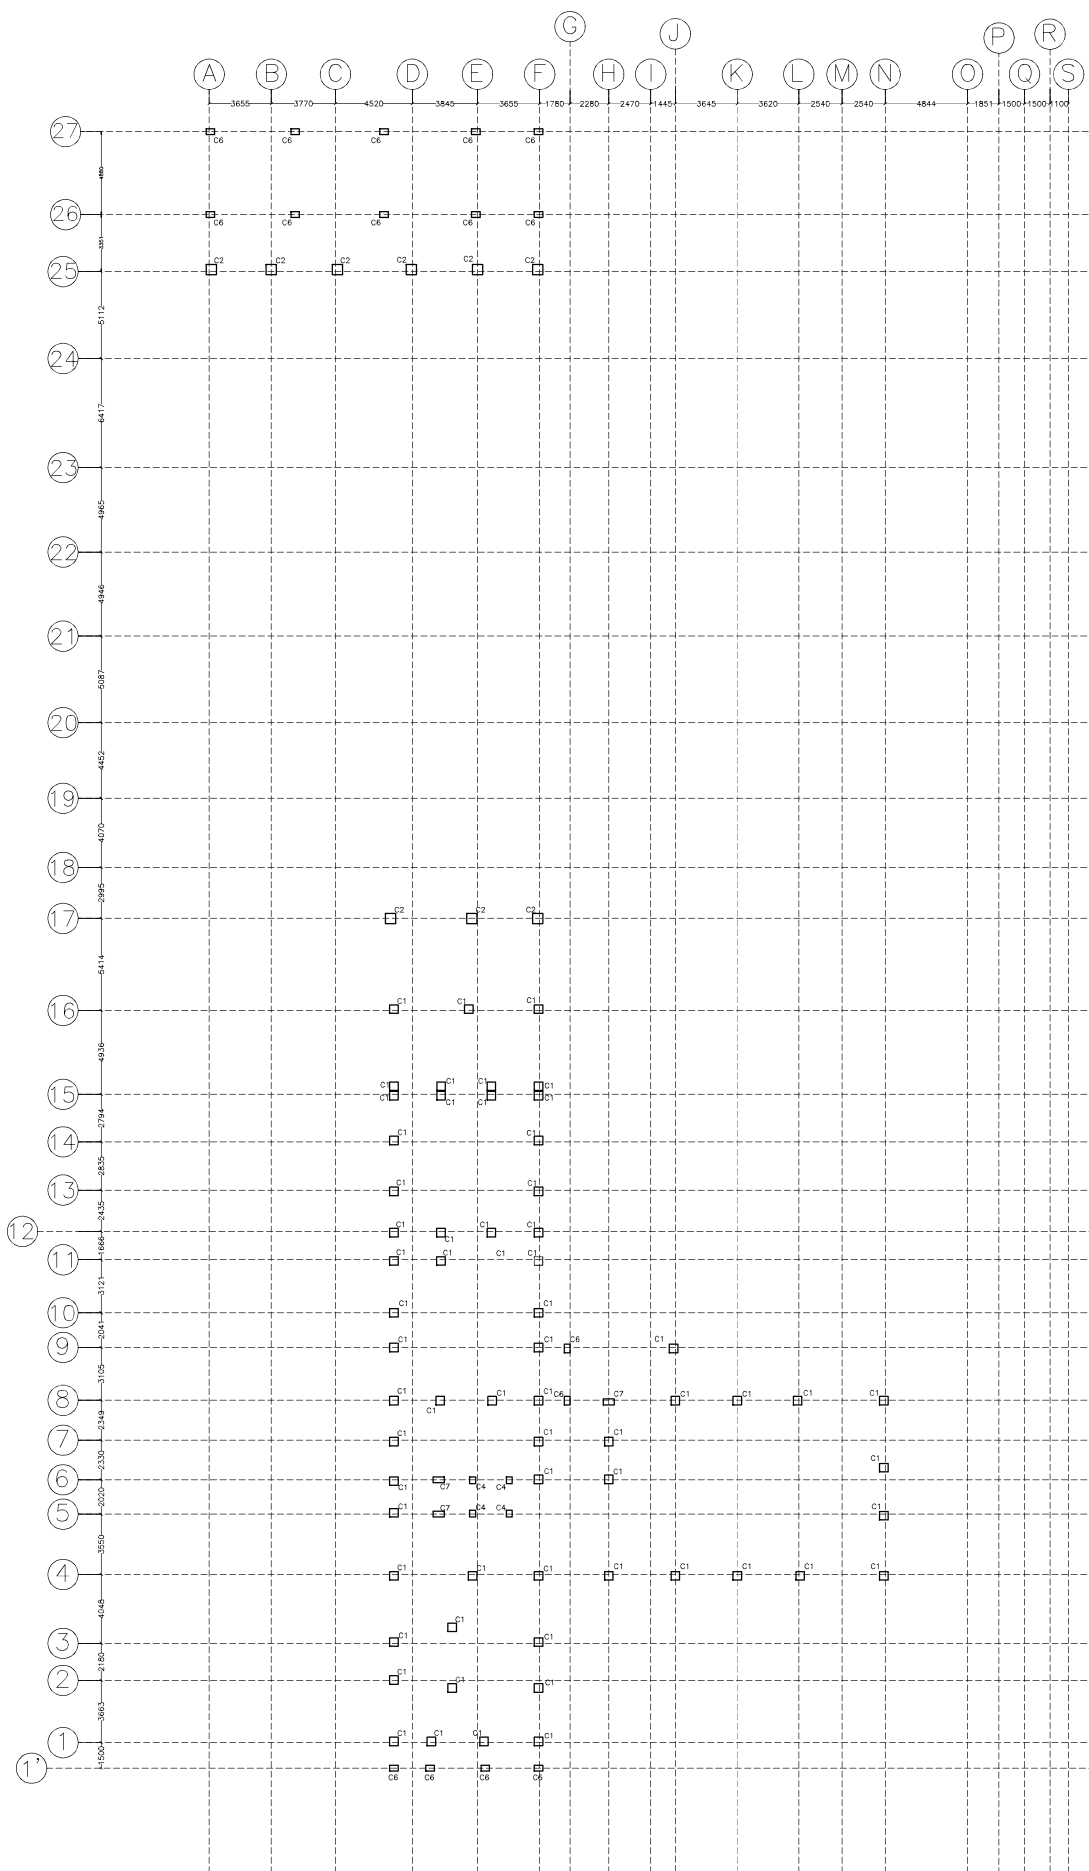

COLUMN LAYOUT AT LEVEL +4.2M

PROJECT TITLE :-
**PROPOSED CONVENTION CENTER
 AT JONGLAPARA LOCALITY AT
 RESUBELPARA, NORTH GARO
 HILLS, MEGHALAYA- PHASE 2**

CLIENT:
Meghalaya Age Limited

FOR APPROVAL	RO		

DRAWING TITLE
 COLUMN LAYOUT AT LEVEL
 +4.2M

DRAWING NO. :-
AR24/MAL/C8/ROM/ST-08 SHEET NO.
ST-3

SCALE: **NTS** DATE: **24.08.24** REVISION NO. -R0

DRAWN BY: DESIGNED BY: APPROVED BY :-
 A.M.


REF NO:- **AR24/MAL/C9/CH_2/AR-01**

ARCHITECTURAL CONSULTANT :-

ARCHOPOLIS
 ARCHITECTURE • URBAN PLANNING • TRANSPORT PLANNING • LANDSCAPE

17/13, BAISNABGHATA ROAD, KOLKATA-700047

CONTACT: +91- 9674590982; 9830504051
 archopolis@gmail.com

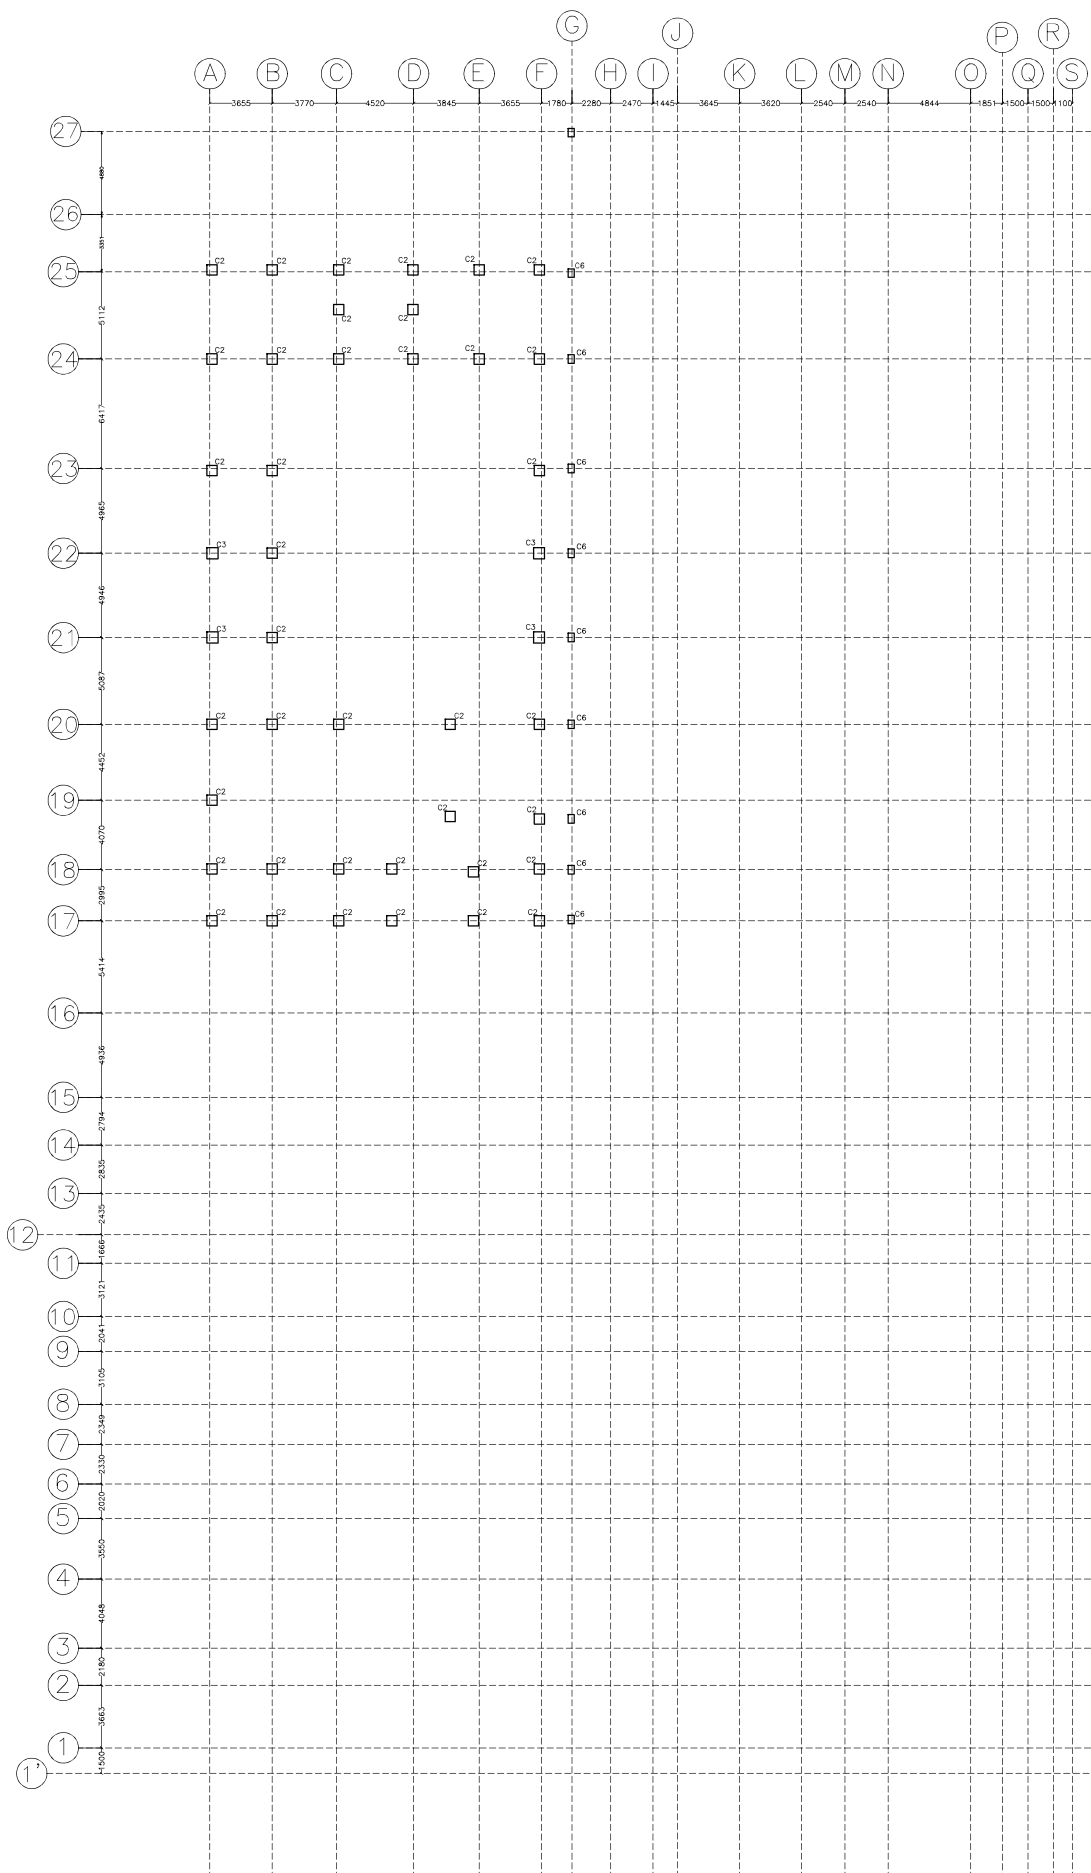

COLUMN AT LEVEL +5.6

PROJECT TITLE :-

**PROPOSED CONVENTION CENTER
AT JONGLAPARA LOCALITY AT
RESUBELPARA, NORTH GARO
HILLS, MEGHALAYA- PHASE 2**

CLIENT:

Meghalaya Age Limited

FOR APPROVAL	RO		

DRAWING TITLE	COLUMN AT LEVEL +5.6
---------------	----------------------

DRAWING NO. :- AR24/MAL/C8/ROM/ST-09	SHEET NO. ST-09
--	---------------------------

SCALE: NTS	DATE: 24.08.24	REVISION NO. :-RO
DRAWN BY:	DESIGNED BY:	APPROVED BY :- A.M.

REF NO:- **AR24/MAL/C9/CH_2/AR-01**



 
 

ARCHITECTURAL CONSULTANT :-

ARCHOPOLIS
ARCHITECTURE • INTERIOR DESIGN • TRANSPORT PLANNING • LANDSCAPE

17/13, BAISNABGHATA ROAD, KOLKATA-700047

CONTACT: +91- 9674590982; 9830504051
archopolis@gmail.com

TOP REINF.
BOTTOM REINF.
OF FOUNDATION

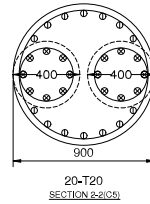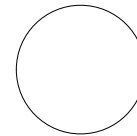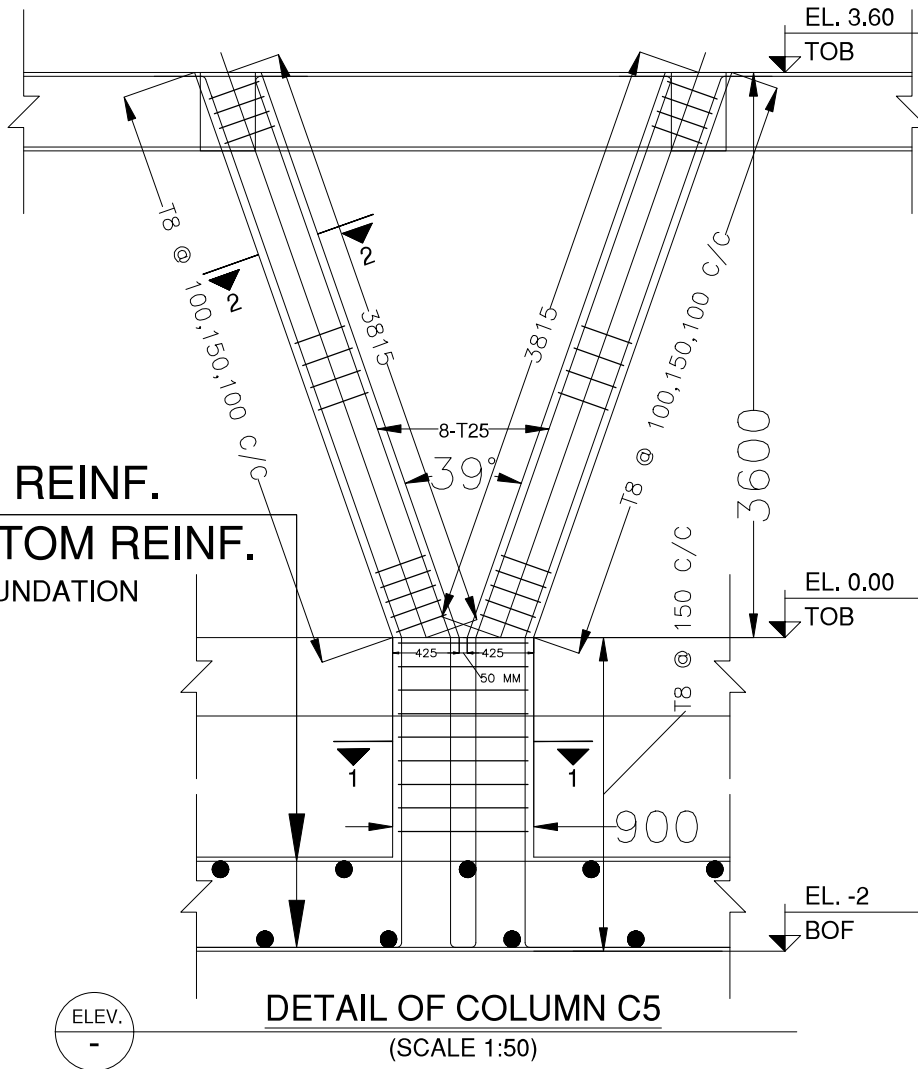

Ø T20

PROJECT TITLE :-
**PROPOSED CONVENTION CENTER
AT JONGLAPARA LOCALITY AT
RESUBELPARA, NORTH GARO
HILLS, MEGHALAYA- PHASE 2**

CLIENT:
Meghalaya Age Limited

FOR APPROVAL	RO		

DRAWING TITLE
**COLUMN SCHEDULE &
DETAIL**

DRAWING NO. :- **AR24/MAL/C8/ROM/ST-11** SHEET NO. **ST-11**

SCALE: **NTS** DATE: **24.08.24** REVISION NO. :- **40**

DRAWN BY: **DESIGNED BY: APPROVED BY: A.M.**


REF NO:- **AR24/MAL/C9/CH_2/AR-01**

ARCHITECTURAL CONSULTANT :-

ARCHOPOLIS

17/13, BAINABGHATA ROAD, KOLKATA-700047

CONTACT: +91- 9674590962; 9830504051
archopolis@gmail.com

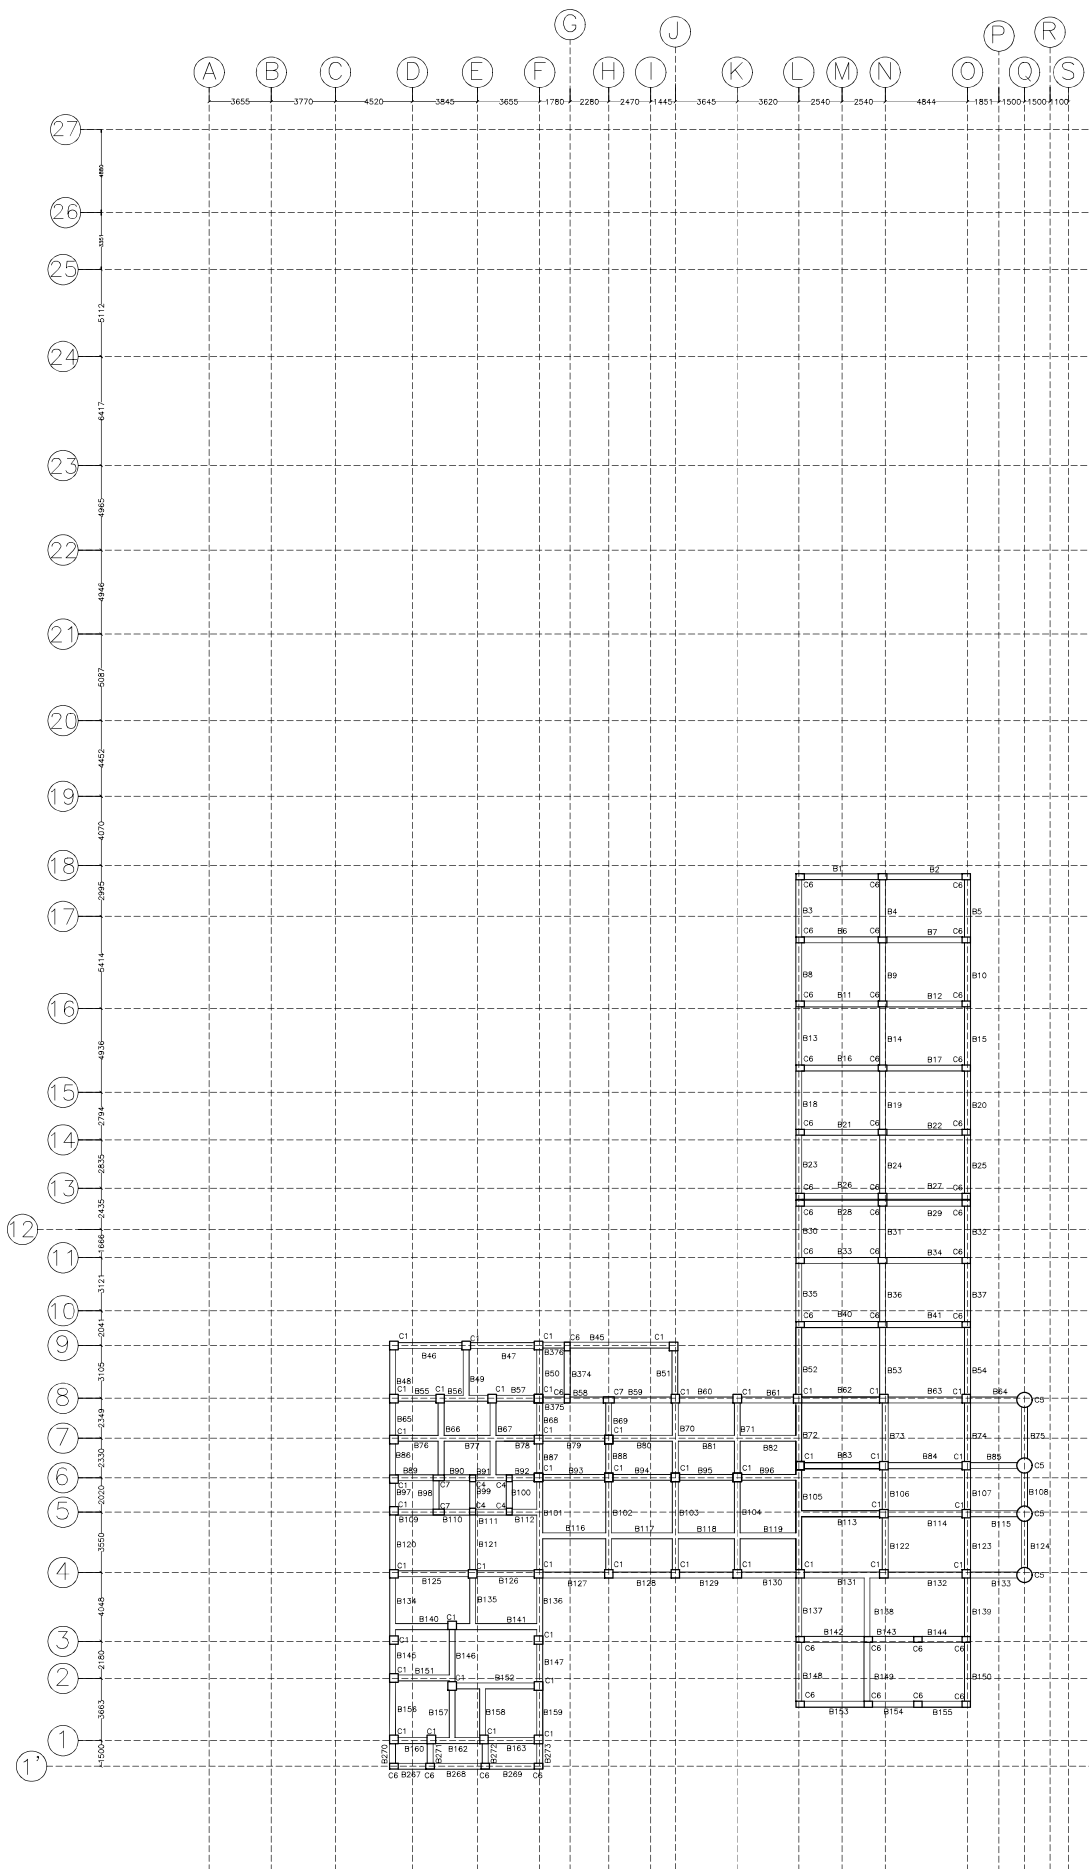

BEAM & SLAB LAYOUT AT LEVEL -10.2M

PROJECT TITLE :-

**PROPOSED CONVENTION CENTER
AT JONGLAPARA LOCALITY AT
RESUBELPARA, NORTH GARO
HILLS, MEGHALAYA- PHASE 2**

CLIENT:

Meghalaya Age Limited

FOR APPROVAL	RO		

DRAWING TITLE

BEAM & SLAB LAYOUT AT
LEVEL -10.2M

DRAWING NO. :-

AR24/MAL/C8/ROM/ST-12

SHEET NO.

12

SCALE:

NTS

DATE:

24.08.24

REVISION NO. -R0

DRAWN BY:

DESIGNED BY:

APPROVED BY :-
A.M.


REF NO:-

ARCHITECTURAL CONSULTANT :-

ARCHOPOLIS
ARCHITECTURE • URBAN PLANNING • TRANSPORT PLANNING • LANDSCAPE

17/13, BAISNABGHATA ROAD, KOLKATA-700047

CONTACT: +91- 9674590982; 9830504051
archopolis@gmail.com

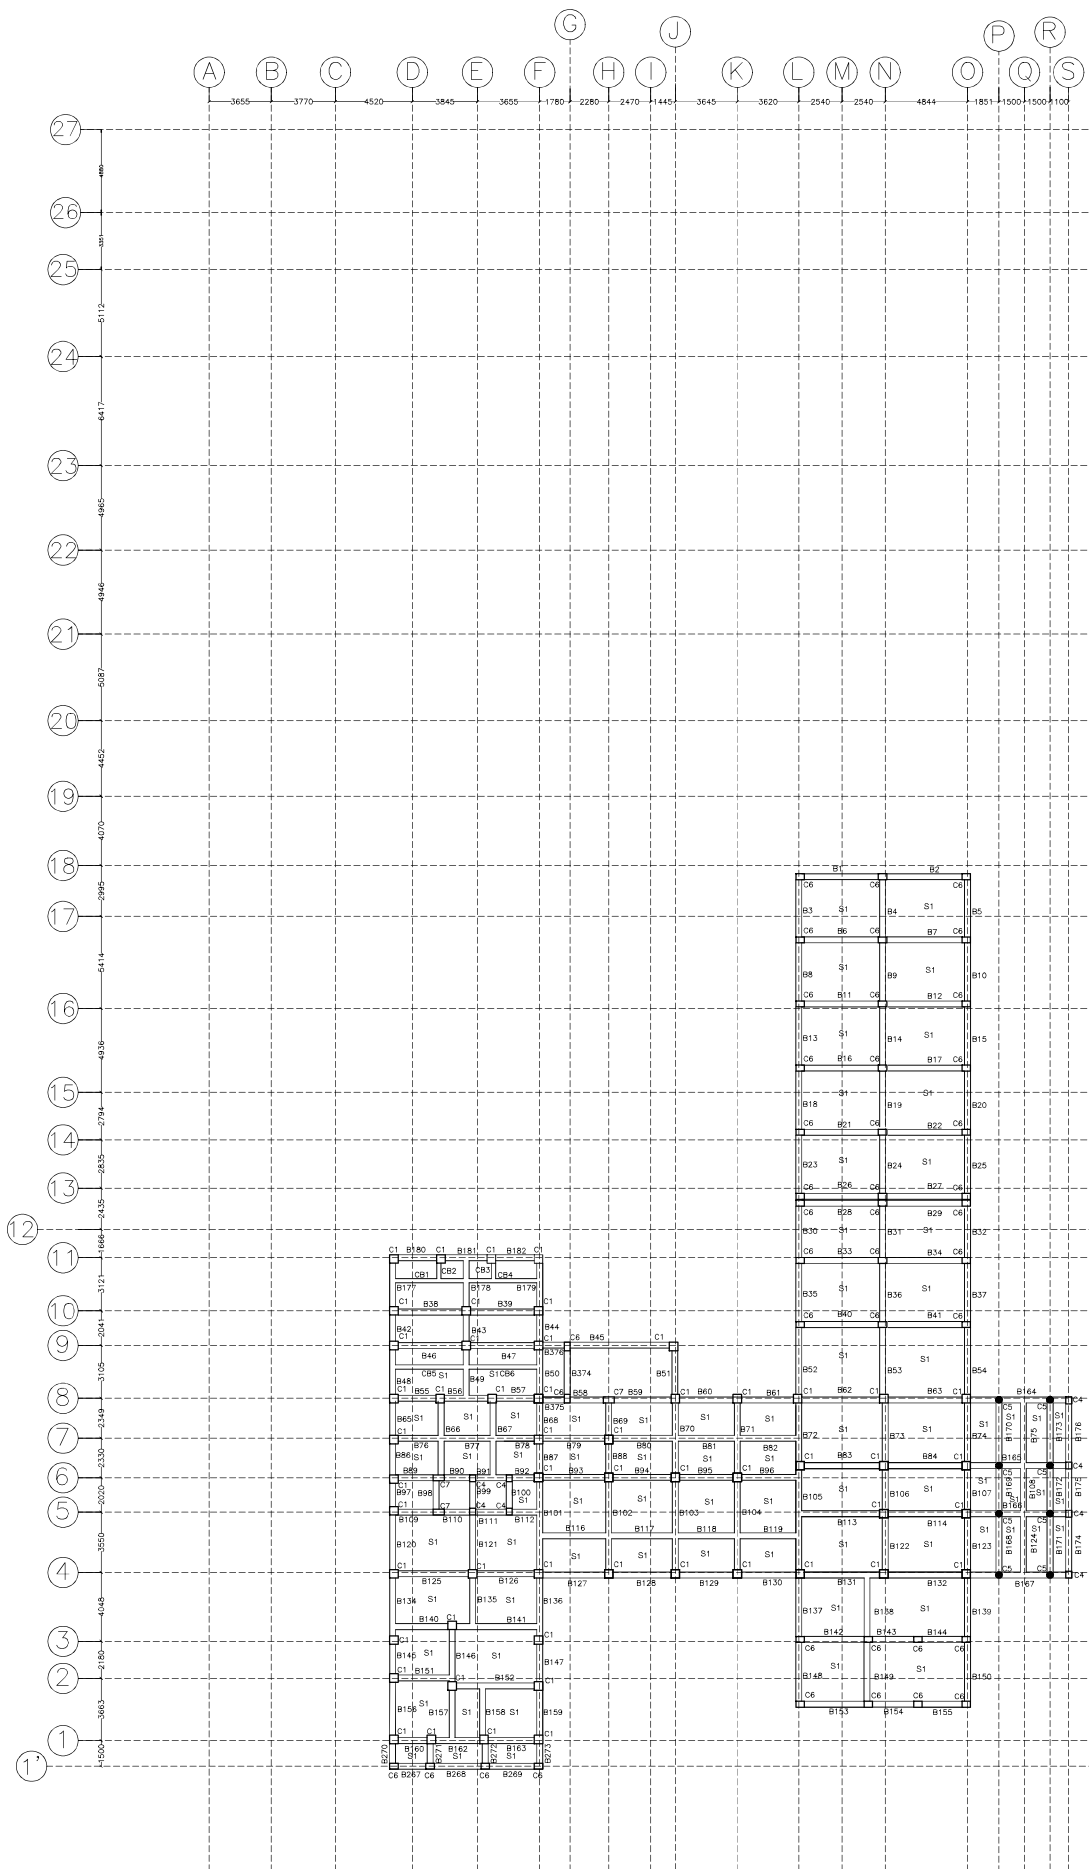

BEAM & SLAB LAYOUT AT LEVEL -6.6M

PROJECT TITLE :-

**PROPOSED CONVENTION CENTER
AT JONGLAPARA LOCALITY AT
RESUBELPARA, NORTH GARO
HILLS, MEGHALAYA- PHASE 2**

CLIENT:

Meghalaya Age Limited

FOR APPROVAL	RO		

DRAWING TITLE

BEAM & SLAB LAYOUT AT
LEVEL -6.6M

DRAWING NO. :-
AR24/MAL/C8/ROM/ST-13

SHEET NO.
13

SCALE: **NTS** DATE: **24.08.24** REVISION NO. -R0

DRAWN BY: DESIGNED BY: APPROVED BY :-
A.M.


REF NO:-

ARCHITECTURAL CONSULTANT :-

ARCHOPOLIS
ARCHITECTS • URBAN PLANNING • TRANSPORT PLANNING • LANDSCAPE

17/13, BAISNABGHATA ROAD, KOLKATA-700047

CONTACT: +91- 9674590982; 9830504051
archopolis@gmail.com

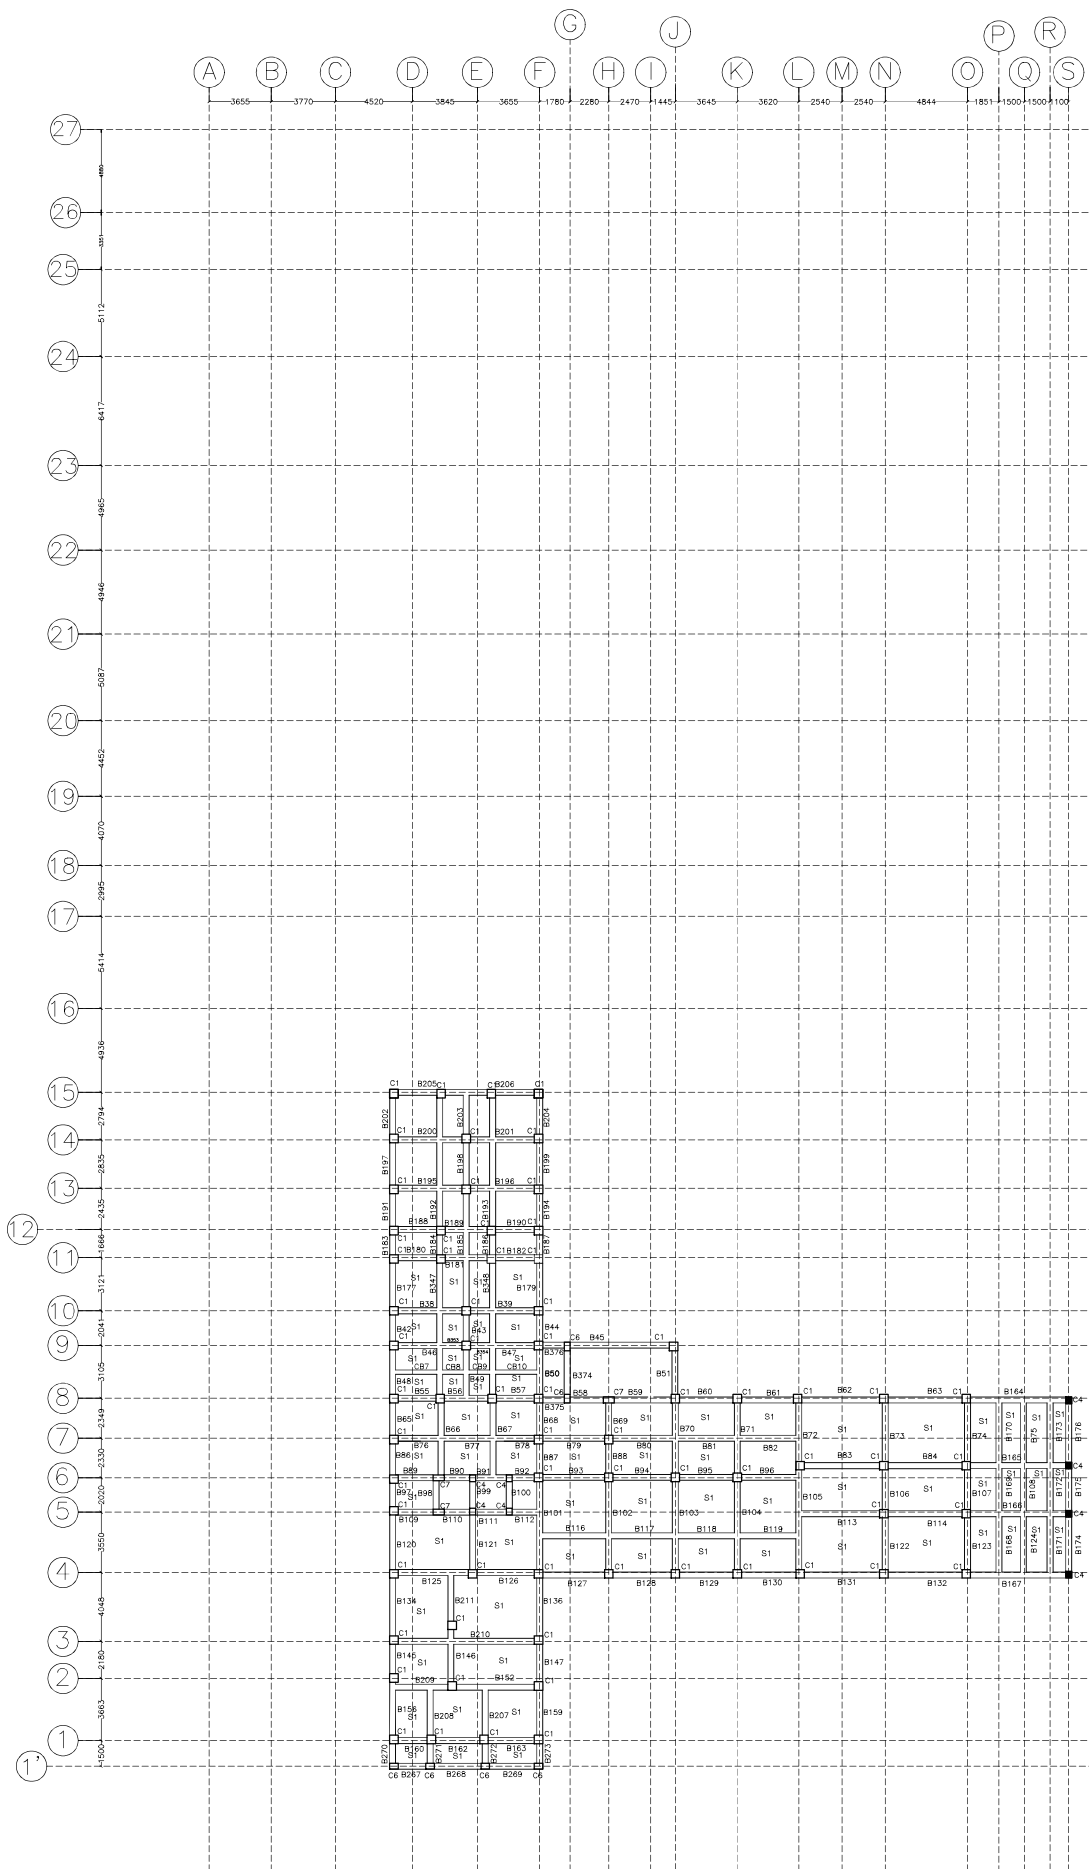

PROJECT TITLE :-

**PROPOSED CONVENTION CENTER
AT JONGLAPARA LOCALITY AT
RESUBELPARA, NORTH GARO
HILLS, MEGHALAYA- PHASE 2**

CLIENT:

Meghalaya Age Limited

FOR APPROVAL	RO		

DRAWING TITLE

BEAM & SLAB LAYOUT AT
LEVEL -3.0M

DRAWING NO. :-

AR24/MAL/C8/ROM/ST-14

SHEET NO.

ST-14

SCALE:

NTS

DATE:

24.08.24

REVISION NO. -R0

DRAWN BY:

DESIGNED BY:

APPROVED BY :-
A.M.


REF NO:-

ARCHITECTURAL CONSULTANT :-

ARCHOPOLIS
ARCHITECTURE • URBAN PLANNING • TRANSPORT PLANNING • LANDSCAPE

17/13, BAISNABGHATA ROAD, KOLKATA-700047

CONTACT: +91- 9674590982; 9830504051
archopolis@gmail.com

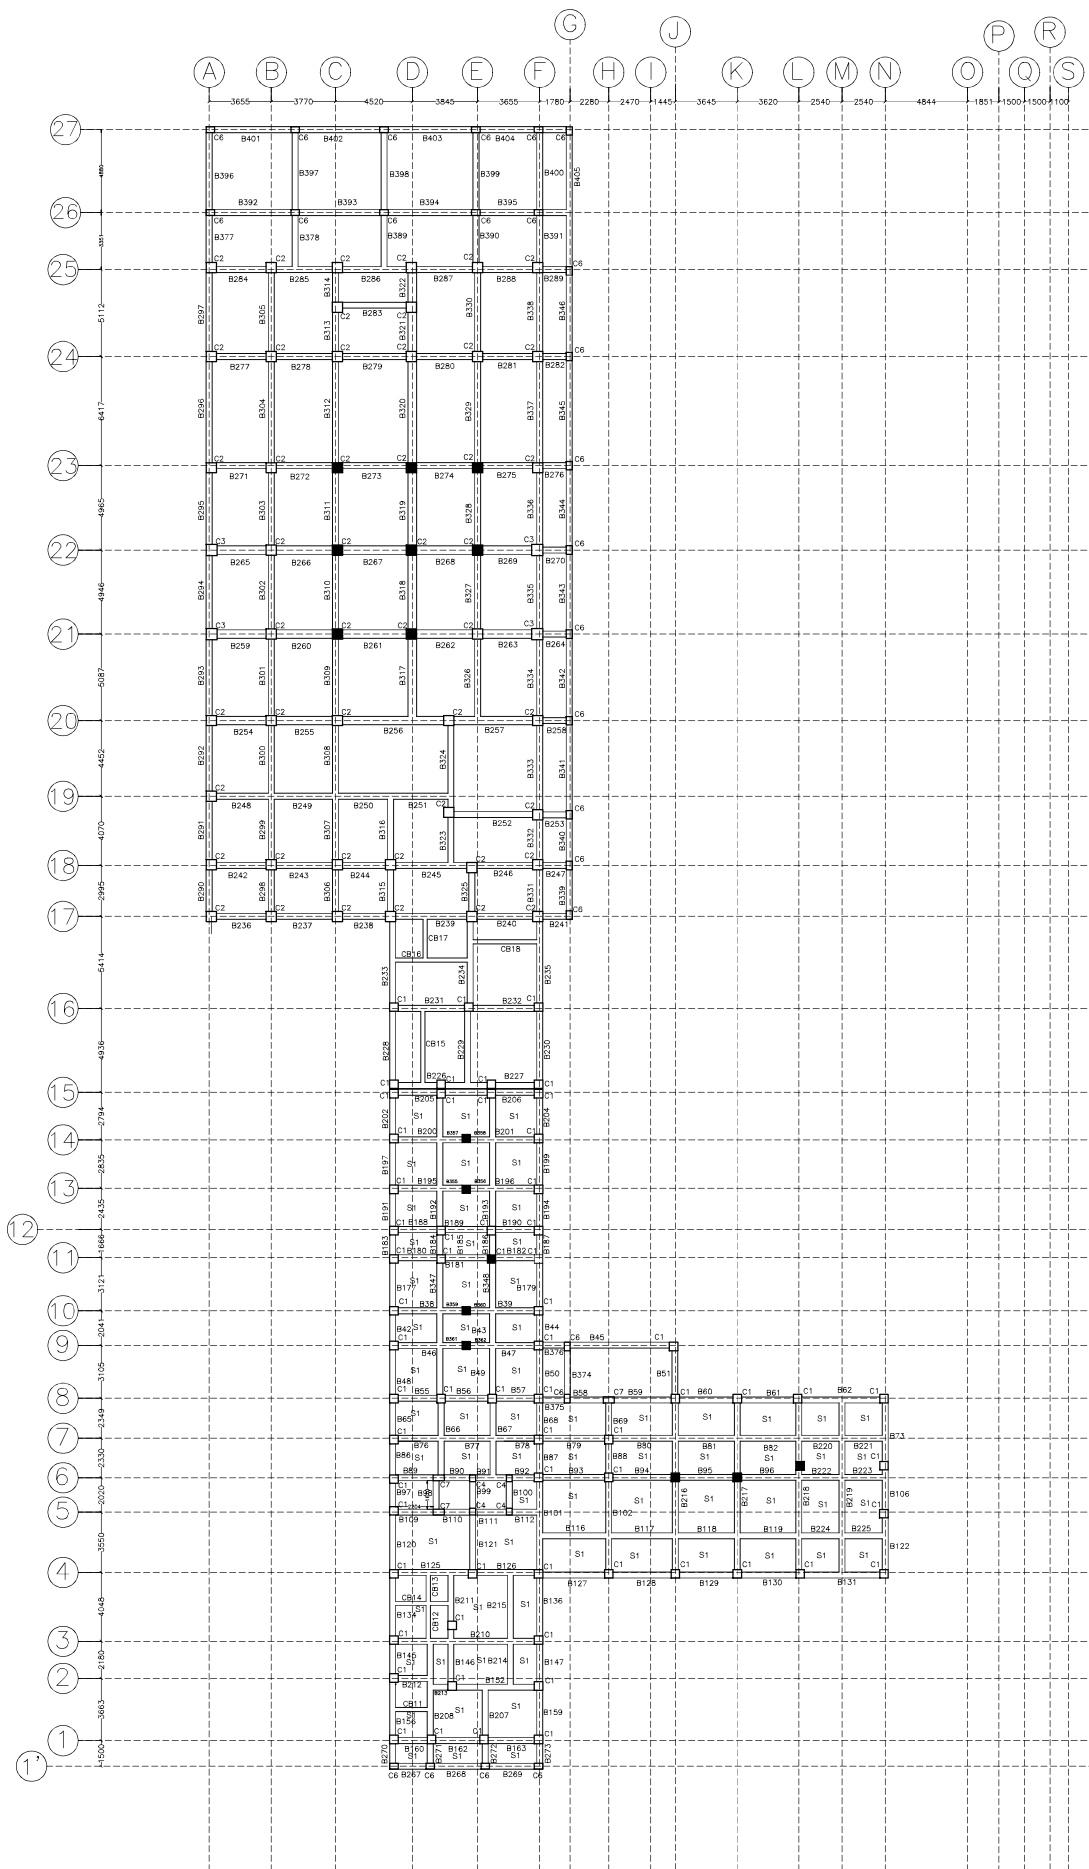

BEAM LAYOUT & SLAB AT LEVEL +0.600M

PROJECT TITLE :-

**PROPOSED CONVENTION CENTER
AT JONGLAPARA LOCALITY AT
RESUBELPARA, NORTH GARO
HILLS, MEGHALAYA- PHASE 2**

CLIENT:

Meghalaya Age Limited

FOR APPROVAL	RO		

DRAWING TITLE

BEAM LAYOUT & SLAB AT
LEVEL +0.600M

DRAWING NO. :-

AR24/MAL/C8/ROM/ST-15

SHEET NO.

ST-15

SCALE:

NTS

DATE:

24.08.24

REVISION NO. -R0

DRAWN BY:

DESIGNED BY:

APPROVED BY :-
A.M.


REF NO:-

ARCHITECTURAL CONSULTANT :-


ARCHOPOLIS
ARCHITECTURE • URBAN PLANNING • TRANSPORT PLANNING • LANDSCAPE

17/13, BAINNABGHATA ROAD, KOLKATA-700047


CONTACT: +91- 9674590982; 9830504051
archopolis@gmail.com

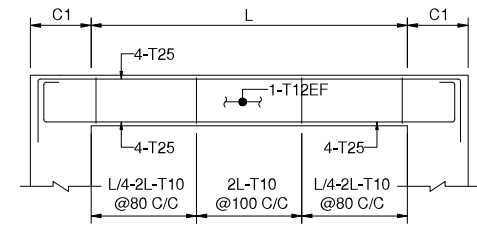


BEAM(350X500)

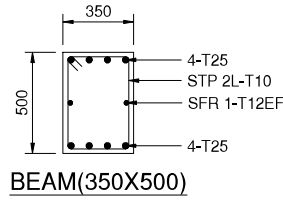


BEAM(350X500)

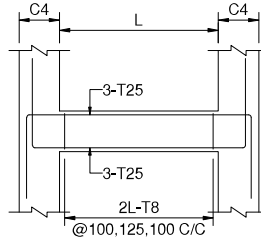


BEAM(350x400)

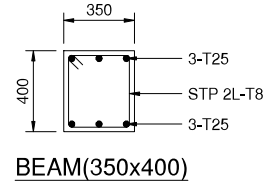


BEAM(350x400)

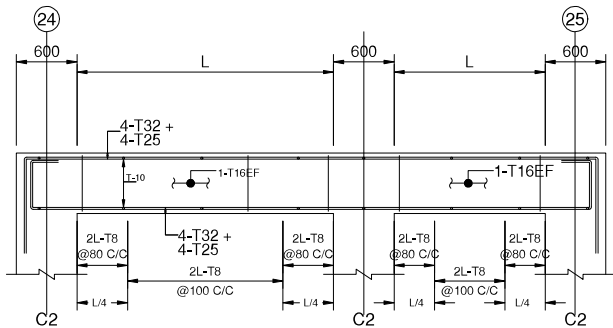


BEAM(500x600)

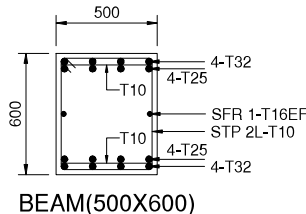

BEAM(500X600)

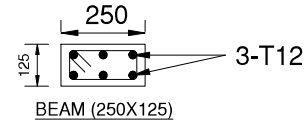


BEAM (250X125)

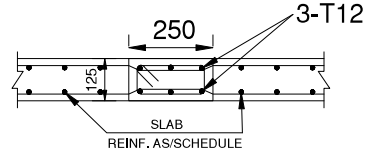


CONCEALED BEAM DETAILS (250X125)

BEAM SCHEDULE (M25 : Fe500)

BEAM NUMBERS	SIZE		BOTTOM REINFORCEMENT			TOP REINFORCEMENT			SHEAR STIRRUPS
	B	D	LEFT	MID SPAN	RIGHT	LEFT	MID SPAN	RIGHT	LEFT,MID SPAN,RIGHT
B1-B88,B90,B92-B96,B101-B108,B110,B112-B253,B258,B264,B270-B320,B323-B338,B347-B349,B339-B346,B351-B373	350	500	4-T25	4-T25	4-T25	4-T25	4-T25	4-T25	2L-T10@80,100,80 C/C SFR 1-T12EF
B97-B100,B89,B91,B109,B111	350	400	3-T25	3-T25	3-T25	3-T25	3-T25	3-T25	2L-T8 @100,125,100 C/C
B254-B257,B259-B263,B265-B269,B321,B322,B350	500	600	4-T32+4-T25	4-T32+4-T25	4-T32+4-T25	4-T32+4-T25	4-T32+4-T25	4-T32+4-T25	2L-T10@80,100,80 C/C SFR 1-T16EF
CB1-CB18	250	125	3-T12	3-T12	3-T12	3-T12	3-T12	3-T12	2L-T8 @125 C/C

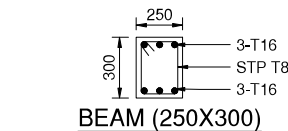

BEAM (250X300)

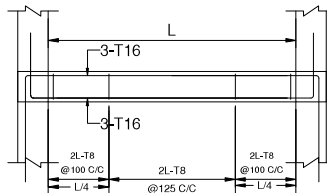

BEAM DETAILS (250X300)

PROJECT TITLE :-
**PROPOSED CONVENTION CENTER
AT JONGLAPARA LOCALITY AT
RESUBELPARA, NORTH GARO
HILLS, MEGHALAYA- PHASE 2**

CLIENT:
Meghalaya Age Limited

FOR APPROVAL	RO		

DRAWING TITLE
BEAM SCHEDULE & DETAIL

DRAWING NO. :- **AR24/MAL/C8/ROM/ST-18** SHEET NO. **ST-18**

SCALE: **NTS** DATE: **24.08.24** REVISION NO. :- **00**

DRAWN BY: DESIGNED BY: APPROVED BY: **A.M.**


REF NO:-

ARCHITECTURAL CONSULTANT :-


ARCHOPOLIS

17/13, BAINABGHATA ROAD, KOLKATA-700047

CONTACT:- +91- 9674590962; 9830504051
archopolis@gmail.com

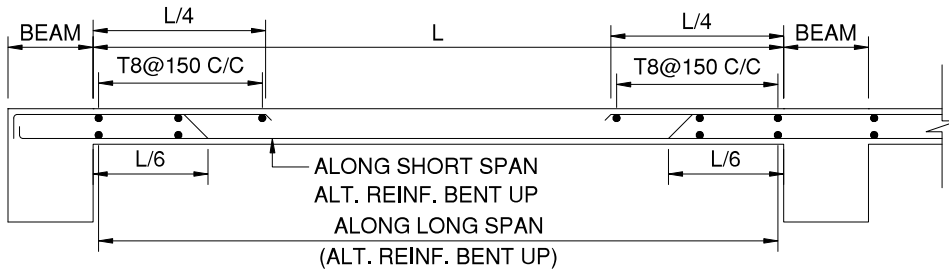

TYPICAL SLAB SECTION
(TWO WAY) (125 THK)

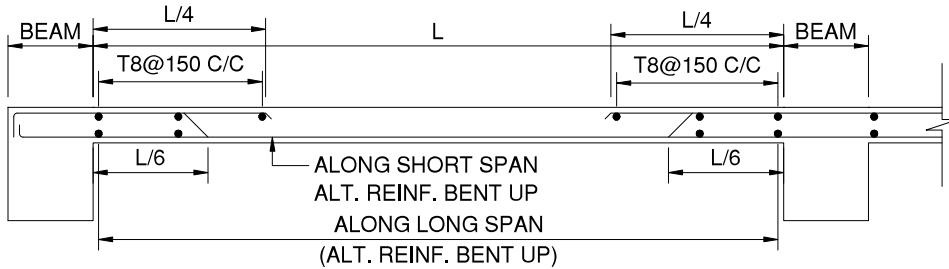

TYPICAL SLAB SECTION
(TWO WAY) (150 THK)

SLAB SCHEDULE (M25 : FE500)

SLAB NUMBERS	THK	TYPE	BOTTOM REINFORCEMENT		TOP REINFORCEMENT		DISTRIBUTION
			SHORT SPAN (BENT UP)	LONG SPAN (BENT UP)	SS CONT.	LS CONT.	
S1	125	2-Way	T8 @ 125	T8 @ 125	T8 @ 125	T8 @ 125	T8 @ 150
S2	150	2-Way	T8 @ 125	T8 @ 125	T8 @ 125	T8 @ 125	T8 @ 150

PROJECT TITLE :-

PROPOSED CONVENTION CENTER
AT JONGLAPARA LOCALITY AT
RESUBELPARA, NORTH GARO
HILLS, MEGHALAYA- PHASE 2

CLIENT:

Meghalaya Age Limited

FOR APPROVAL

RO		

DRAWING TITLE

**SLAB SCHEDULE &
DETAIL**

DRAWING NO. :- **AR24/MAL/C8/ROM/ST-19** SHEET NO. **ST-19**


SCALE: **NTS** DATE: **24.08.24** REVISION NO. :- **00**

DRAWN BY: DESIGNED BY: APPROVED BY :- **A.M.**

REF NO:-

ARCHITECTURAL CONSULTANT :-

ARCHOPOLIS
17/13, BAINABGHATA ROAD, KOLKATA-700047
CONTACT: +91- 9674590962; 9830504051
archopolis@gmail.com

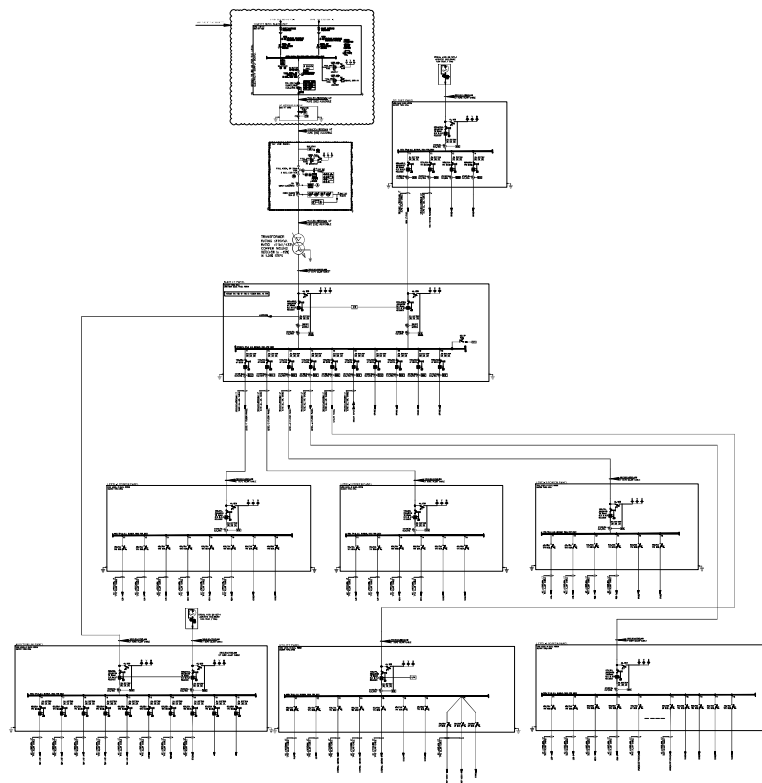

BUILDING ELECTRICAL LEGEND	
SYMBOL	
	DECORATIVE WALL UP-DOWN LIGHT
	EXTERNAL WALL LIGHT
	TABLE LAMP
	WALL MOUNTED FOOT LIGHT
	EXHAUST FAN
	THERMOSTAT
	CEILING LIGHT
	CEILING FAN
	IS A PLUG POINT
	A/C POINT
	MIRROR LIGHT
	HANGING LIGHT
	EQUALLY DISTRIBUTED CEILING LIGHT
	LED STRIP WITH PROFILE
	CEILING HANGING LAMP
	SPLIT AC

PROJECT TITLE :-
PROPOSED CONVENTION CENTER AT JONGLAPARA LOCALITY AT RESUBELPARA, NORTH GARO HILLS, MEGHALAYA-PHASE I

CLIENT:
MEGHALAYA AGE LIMITED

FOR APPROVAL	RO		

DRAWING TITLE **SLD_ELECTRICAL LAYOUT**

DRAWING NO. :- **AR24/MAL/C8/ROM/EL-01** SHEET NO. **EL-01**

SCALE: **NTS** DATE: **23.09.24** REVISION NO. **40**


DRAWN BY: **DESIGNED BY: APPROVED BY: A.M.**

ARCHITECTURAL CONSULTANT :-

ARCHOPOLIS


17/13, BAINABGHATA ROAD, KOLKATA-700047

CONTACT: +91-9674590982; 9830504051
archopolis@gmail.com

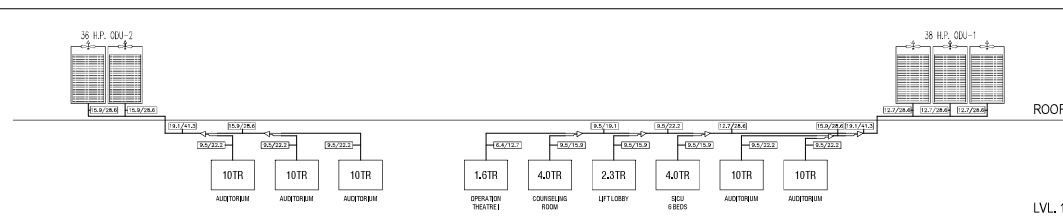

REFRIGERANT PIPING SCHEMATIC DIAGRAM

75.00

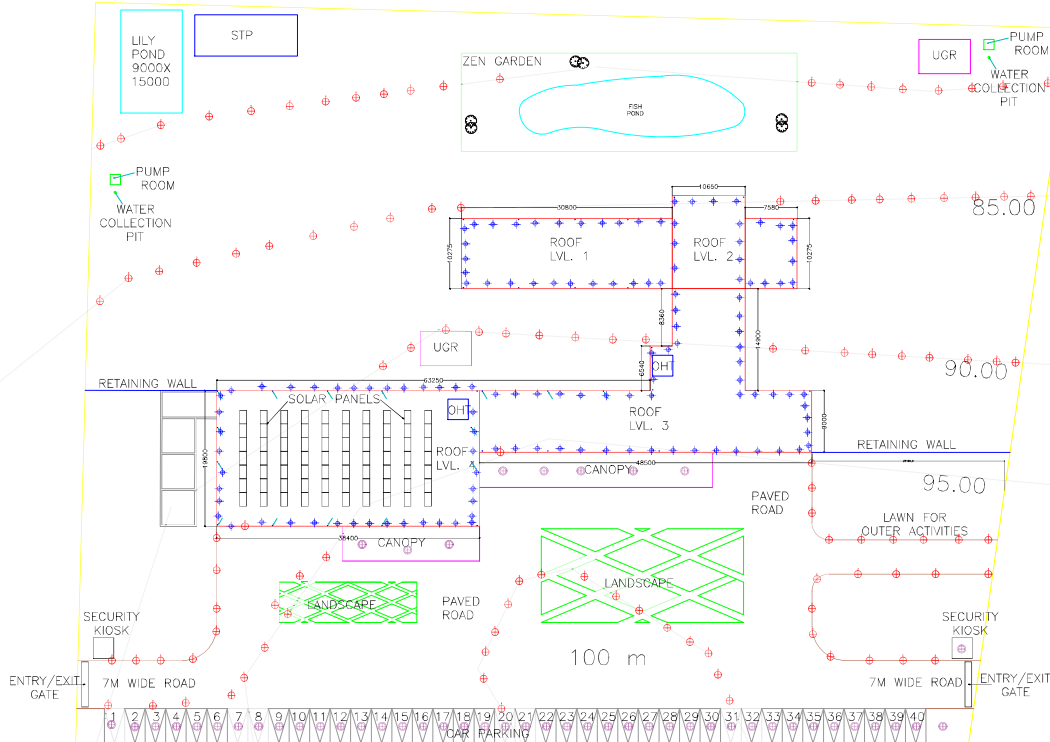

SITE ELECTRICAL LEGEND

SYMBOL	
	IN-GROUND POST LIGHT
	IN-GROUND LAMP POST LIGHT
	BOLLARD LIGHT
	EXTERNAL WALL LIGHT
	LED STRIP WITH PROFILE
	LED UP LIGHT 1.5W
	WALL MOUNTED POST LIGHT
	HIGH MAST
	WIP UP WALLCUTTER
	SWIMMING POOL UNDERWATER LIGHT
	SWIMMING POOL UNDERWATER STEPS LIGHT

PROJECT TITLE :-

PROPOSED CONVENTION CENTER AT
JONGLAPARA LOCALITY AT
RESUBELPARA, NORTH GARO HILLS,
MEGHALAYA-PHASE I

CLIENT:

MEGHALAYA AGE LIMITED

FOR APPROVAL

DRAWING TITLE
MASTER PLAN
ELECTRICAL LAYOUT

DRAWING NO. :-
AR24/MAL/C8/ROM/EL-02

SCALE: NTS

DATE: 23.09.24

DRAWN BY: DESIGNED BY: APPROVED BY: A.M.


ARCHITECTURAL CONSULTANT :-

ARCHOPOLIS

17/13, BAINABGHATA ROAD, KOLKATA-700047

CONTACT: +91-9674590982; 9830504051

archopolis@gmail.com

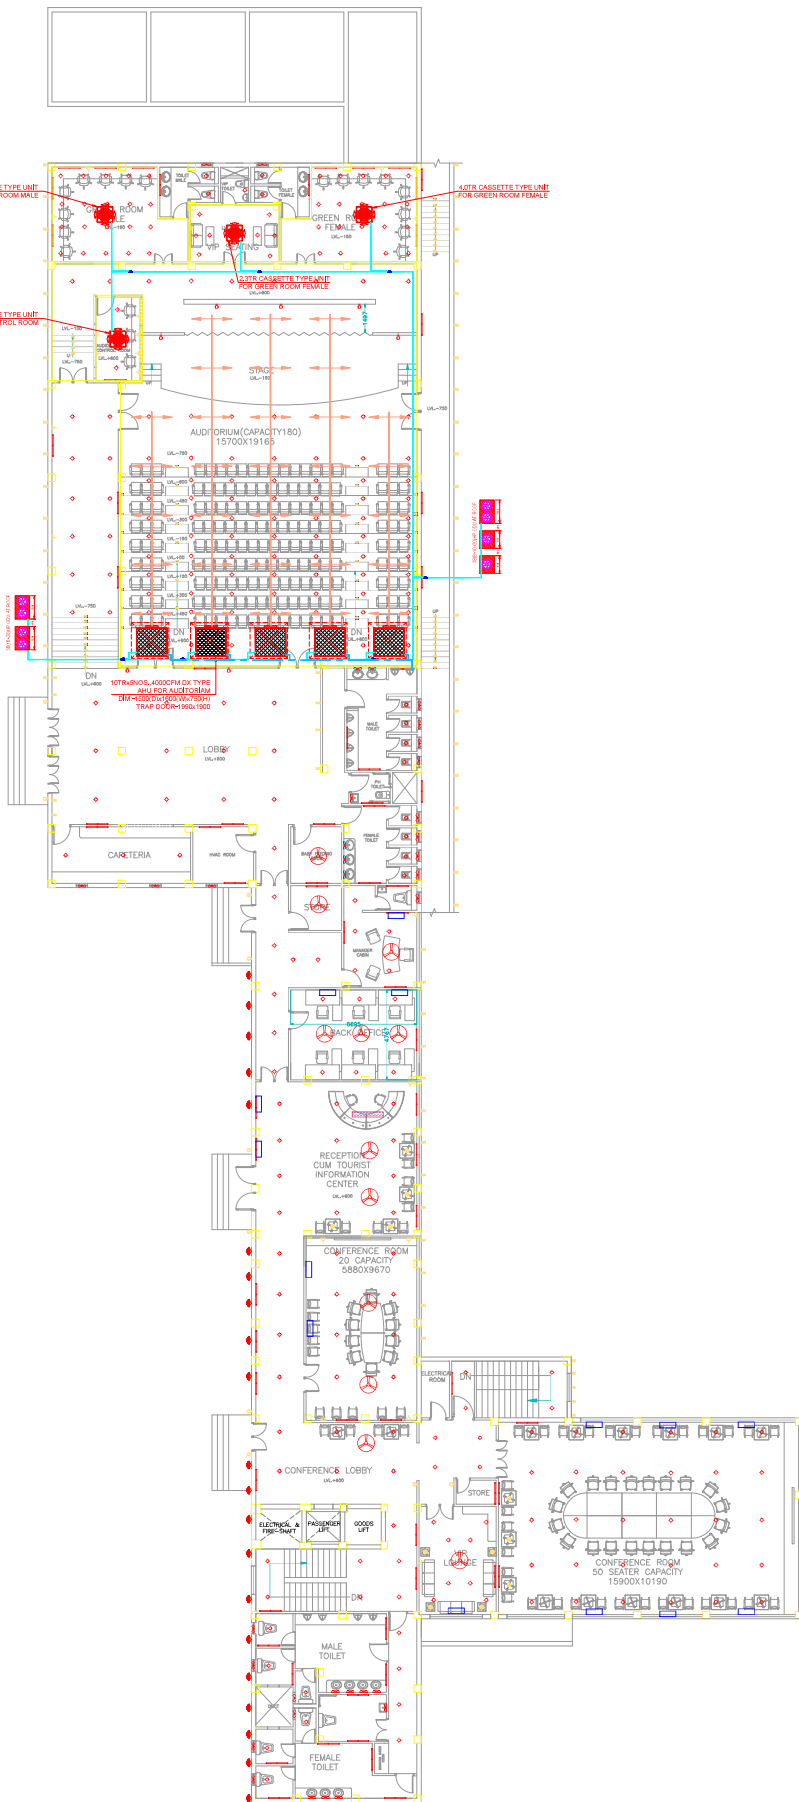

LV1
FLOOR PLANS

BUILDING ELECTRICAL LEGEND	
SYMBOL	
	DECORATIVE WALL UP-DOWN LIGHT
	EXTERNAL WALL LIGHT
	TABLE LAMP
	WALL MOUNTED FOOT LIGHT
	EXHAUST FAN
	TUBELIGHT SINGLE
	CEILING LIGHT
	CEILING FAN
	15 A PLUG POINT
	A/C POINT
	MIRROR LIGHT
	HANGING LIGHT
	DOUBLE SUSPENDED TUBELIGHT
	LED STRIP WITH PROFILE
	CEILING HANGING LAMP
	SPLIT AC

PROJECT TITLE :-
PROPOSED CONVENTION CENTER AT JONGLAPARA LOCALITY AT RESUBELPARA, NORTH GARO HILLS, MEGHALAYA- PHASE 1

CLIENT:
MEGHALAYA AGE LIMITED

FOR APPROVAL	RO		

DRAWING TITLE	LEVEL- 1_ FLOOR PLAN ELECTRICAL LAYOUT
---------------	---


DRAWING NO. :- AR24/MAL/C8/ROM/EL-03		SHEET NO. EL-03
SCALE: NTS	DATE: 23.09.24	REVISION NO. -R0
DRAWN BY:	DESIGNED BY:	APPROVED BY :- A.M.

ARCHITECTURAL CONSULTANT :-

ARCHOPOLIS
ARCHITECTURE • URBAN PLANNING • TRANSPORT PLANNING • LANDSCAPE

17/13, BAISNABGHATA ROAD, KOLKATA-700047

CONTACT: +91- 9674590982; 9830504051
archopolis@gmail.com

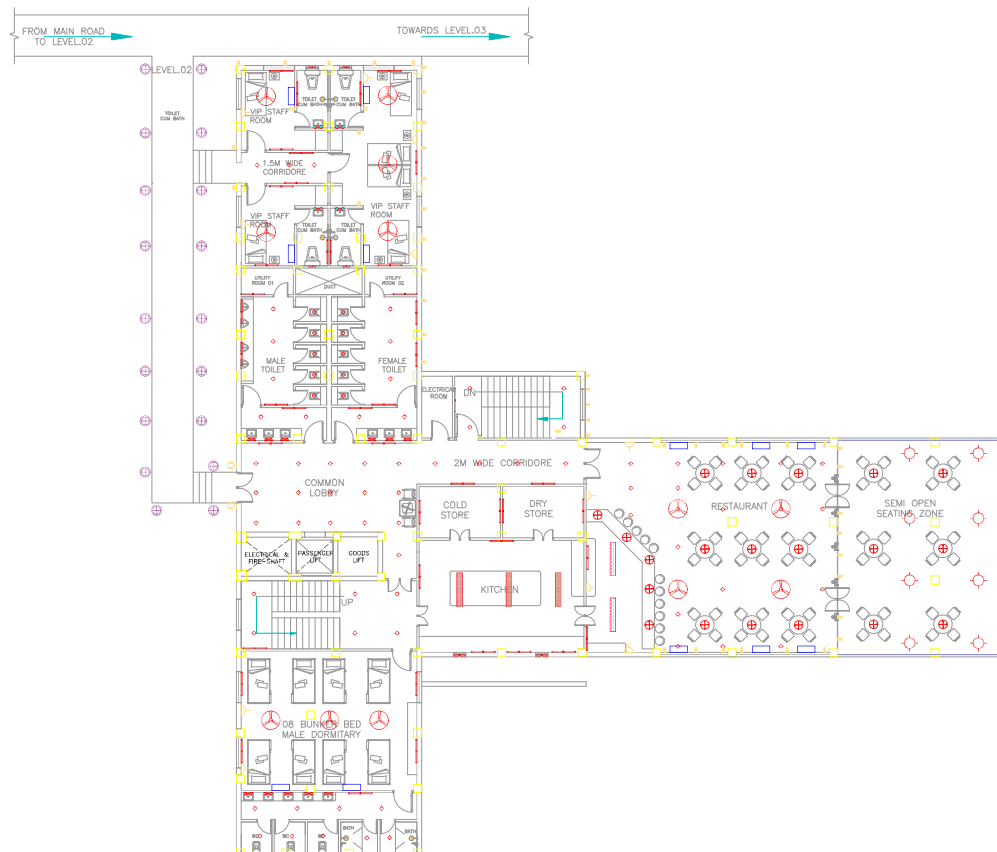

LV2
FLOOR PLANS

BUILDING ELECTRICAL LEGEND	
SYMBOL	
	DECORATIVE WALL UP-DOWN LIGHT
	EXTERNAL WALL LIGHT
	TABLE LAMP
	WALL MOUNTED FOOT LIGHT
	EXHAUST FAN
	TUMBLE DRY
	CEILING LIGHT
	CEILING FAN
	IS A PLUG POINT
	A/C POINT
	MIRROR LIGHT
	HANGING LIGHT
	EQUALLY SUSPENDED CEILING
	LED STRIP WITH PROFILE
	CEILING HANGING LAMP
	SPLIT AC

PROJECT TITLE :-
PROPOSED CONVENTION CENTER AT
JONGLAPARA LOCALITY AT
RESUBELPARA, NORTH GARO HILLS,
MEGHALAYA-PHASE I

CLIENT:
MEGHALAYA AGE LIMITED

FOR APPROVAL	RO		

DRAWING TITLE
LEVEL-2, FLOOR PLAN
ELECTRICAL LAYOUT

DRAWING NO. :-
AR24/MAL/C8/ROM/EL-04

SHEET NO.
EL-04


SCALE: NTS DATE: 23.09.24

DRAWN BY: DESIGNED BY: APPROVED BY :-
A.M.

ARCHITECTURAL CONSULTANT :-
ARCHOPOLIS
17/13, BAINABGHATA ROAD, KOLKATA-700047
CONTACT: +91-9674590982; 9830504051
archopolis@gmail.com

FROM LEVEL 02
TO LEVEL 03

TOWARDS LEVEL 04

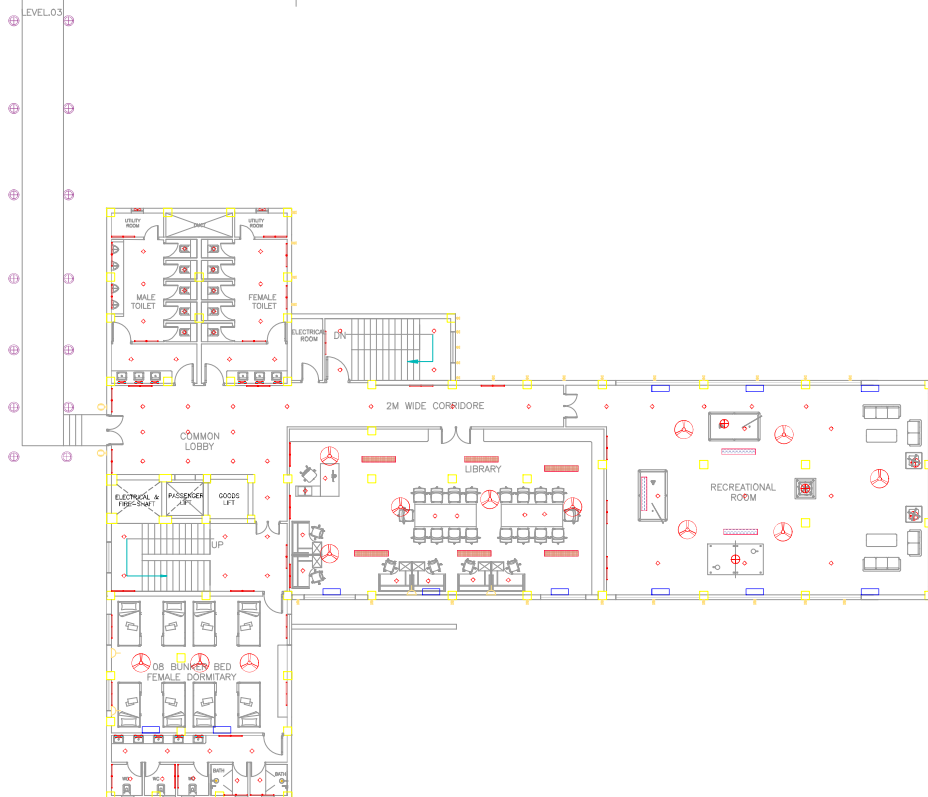

LV3
FLOOR PLANS

BUILDING ELECTRICAL LEGEND	
SYMBOL	
	DECORATIVE WALL UP-DOWN LIGHT
	EXTERNAL WALL LIGHT
	TABLE LAMP
	WALL MOUNTED FOOT LIGHT
	EXHAUST FAN
	THERMOSTAT
	CEILING LIGHT
	CEILING FAN
	TO A PLUG POINT
	A/C POINT
	MIRROR LIGHT
	HANGING LIGHT
	EQUALLY DISTRIBUTED LIGHTING
	LED STRIP WITH PROFILE
	CEILING HANGING LAMP
	SPLIT AC

PROJECT TITLE :-
**PROPOSED CONVENTION CENTER AT
JONGLAPARA LOCALITY AT
RESUBELPARA, NORTH GARO HILLS,
MEGHALAYA-PHASE I**

CLIENT:
MEGHALAYA AGE LIMITED

FOR APPROVAL	RO		


DRAWING TITLE **LEVEL- 3_ FLOOR PLAN
ELECTRICAL LAYOUT**

DRAWING NO. :- **AR24/MAL/C8/ROM/EL-05** SHEET NO. **EL-05**

SCALE: **NTS** DATE: **23.09.24** REVISION NO. **400**

DRAWN BY: **DESIGNED BY: APPROVED BY: A.M.**

ARCHITECTURAL CONSULTANT :-
ARCHOPOLIS
17/13, BAINNABGHATA ROAD, KOLKATA-700047
CONTACT: +91-9674590982; 9830504051
archopolis@gmail.com

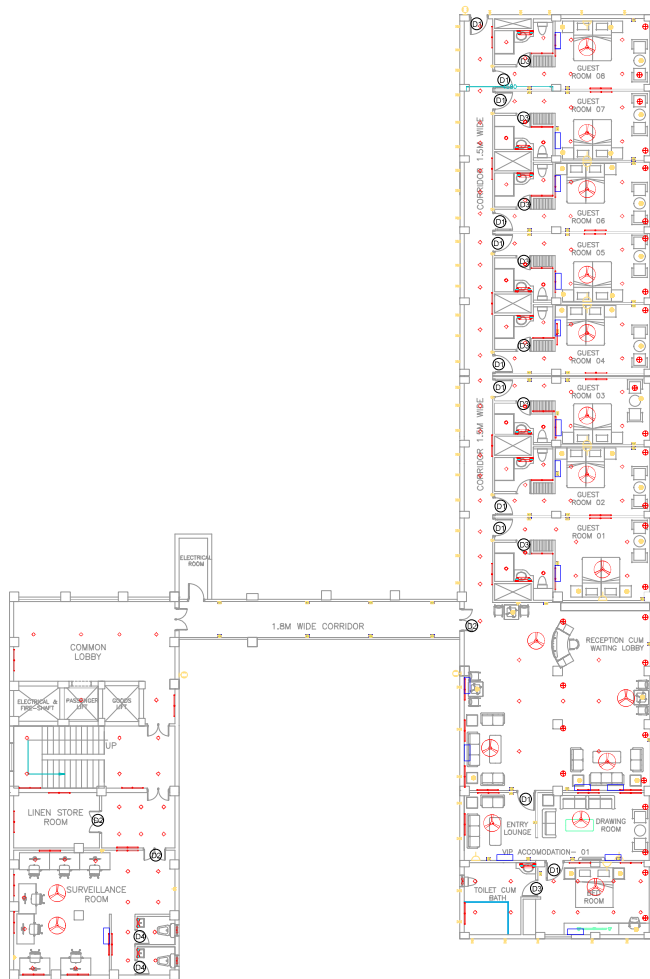

LV4
FLOOR PLANS

BUILDING ELECTRICAL LEGEND	
SYMBOL	
	DECORATIVE WALL UP-DOWN LIGHT
	EXTERNAL WALL LIGHT
	TABLE LAMP
	WALL MOUNTED FLOOR LAMP
	EXHAUST FAN
	STANDARD SWITCH
	CEILING LIGHT
	CEILING FAN
	15 A PLUG POINT
	A/C POINT
	WINDOW LIGHT
	PENDANT LIGHT
	DOUBLE SUSPENDED CEILING
	LED STRIP WITH PROFILE
	CEILING HANGING LAMP
	SPLIT AC

PROJECT TITLE :-
PROPOSED CONVENTION CENTER AT JONGLAPARA LOCALITY AT RESUBELPARA, NORTH GARO HILLS, MEGHALAYA- PHASE 2

CLIENT:
MEGHALAYA AGE LIMITED

FOR APPROVAL	RO		

DRAWING TITLE	LEVEL- 4, FLOOR PLAN ELECTRICAL LAYOUT
---------------	---

DRAWING NO. :-	AR24/MAL/C8/ROM/EL-06	SHEET NO.
		EL-06

SCALE:	DATE:	REVISION NO. :-
NTS	23.09.24	
DRAWN BY:	DESIGNED BY:	APPROVED BY :-
		A.M.

ARCHITECTURAL CONSULTANT :-

ARCHOPOLIS

17/13, BAINNABGHATA ROAD, KOLKATA-700047

CONTACT :- 91-9674590982; 9830504051
archopolis@gmail.com












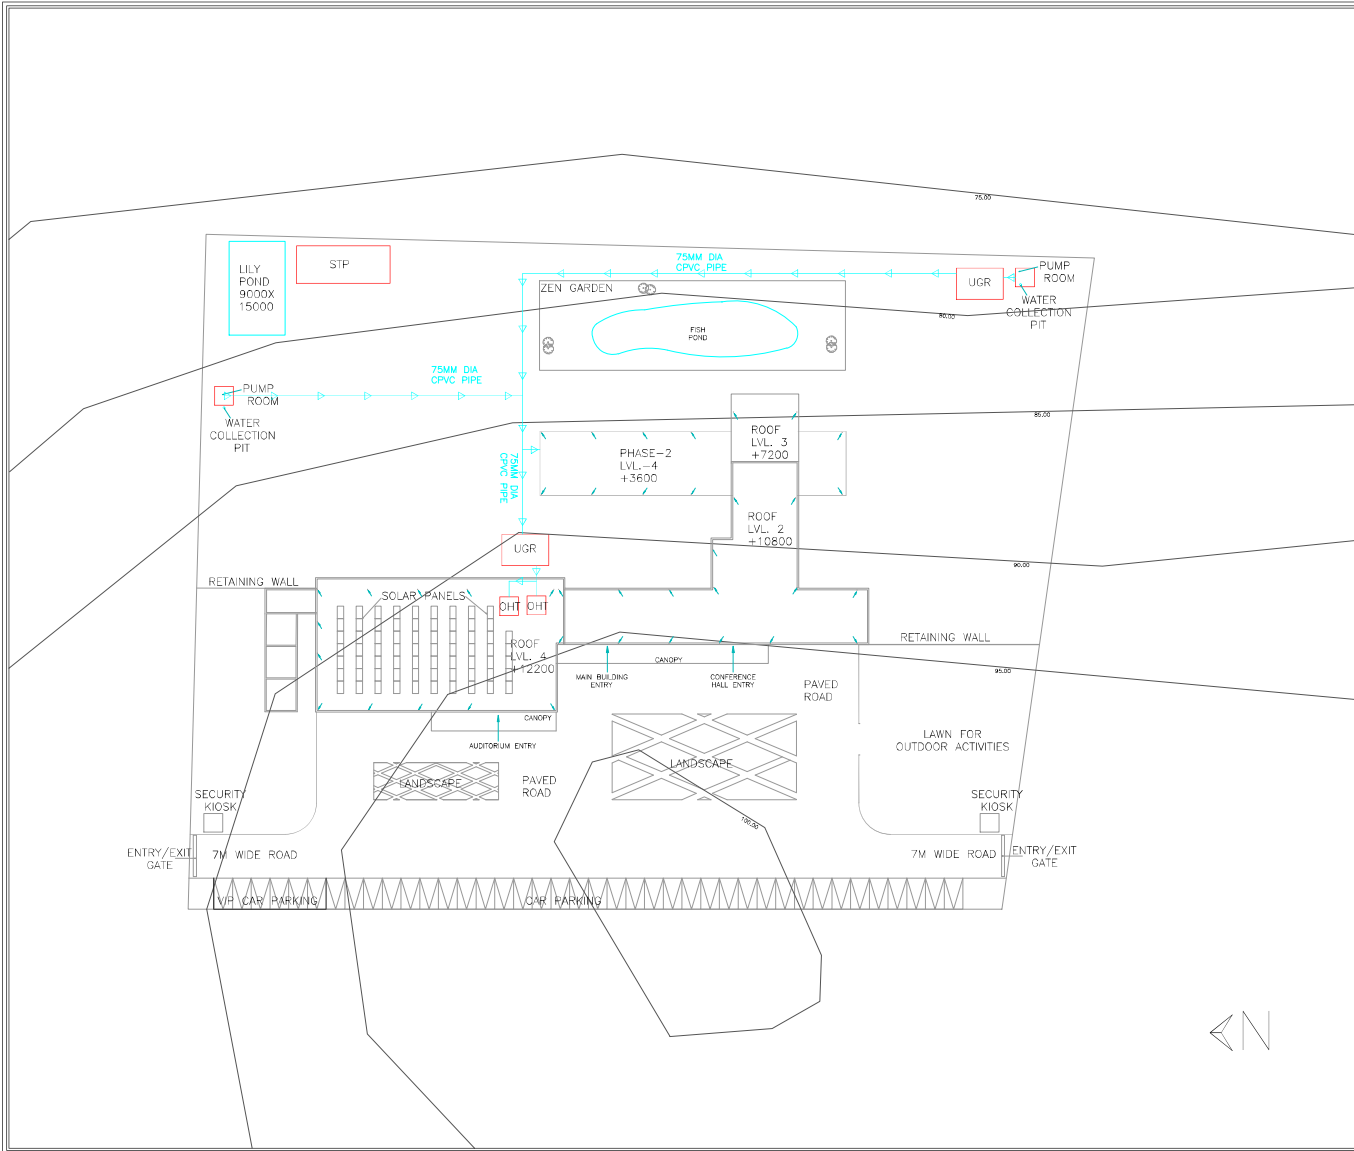

NOTE

	450x450mm CATCH BASIN
	600x600mm RECTANGULAR SEWERAGE MANHOLE
	SLOPE
	RAIN WATER HARVESTING TANK
	SEWERAGE PIPE
	RAIN WATER PIPE
	WASTE WATER PIPE
	DRAIN CHANNEL
	WATER SUPPLY
	INSPECTION PIT
	SPRINKLER

PROJECT TITLE :-

**PROPOSED CONVENTION CENTER AT
JONGLAPARA LOCALITY AT
RESUBELPARA, NORTH GARO HILLS,
MEGHALAYA-PHASE 2**

CLIENT:

MEGHALAYA AGE LIMITED

FOR APPROVAL	RO		

DRAWING TITLE **DRINKING WATER LAYOUT**

DRAWING NO. :-	SHEET NO.
AR24/MAL/C8/ROM/SNP-01	SNP-01


SCALE:	DATE:	REVISION NO. :-
NTS	23.09.24	400
DRAWN BY:	DESIGNED BY:	APPROVED BY :-
		A.M.

ARCHITECTURAL CONSULTANT :-

ARCHOPOLIS

17/13, BAINNABGHATA ROAD, KOLKATA-700047

CONTACT: +91-9674590982; 9830504051
archopolis@gmail.com

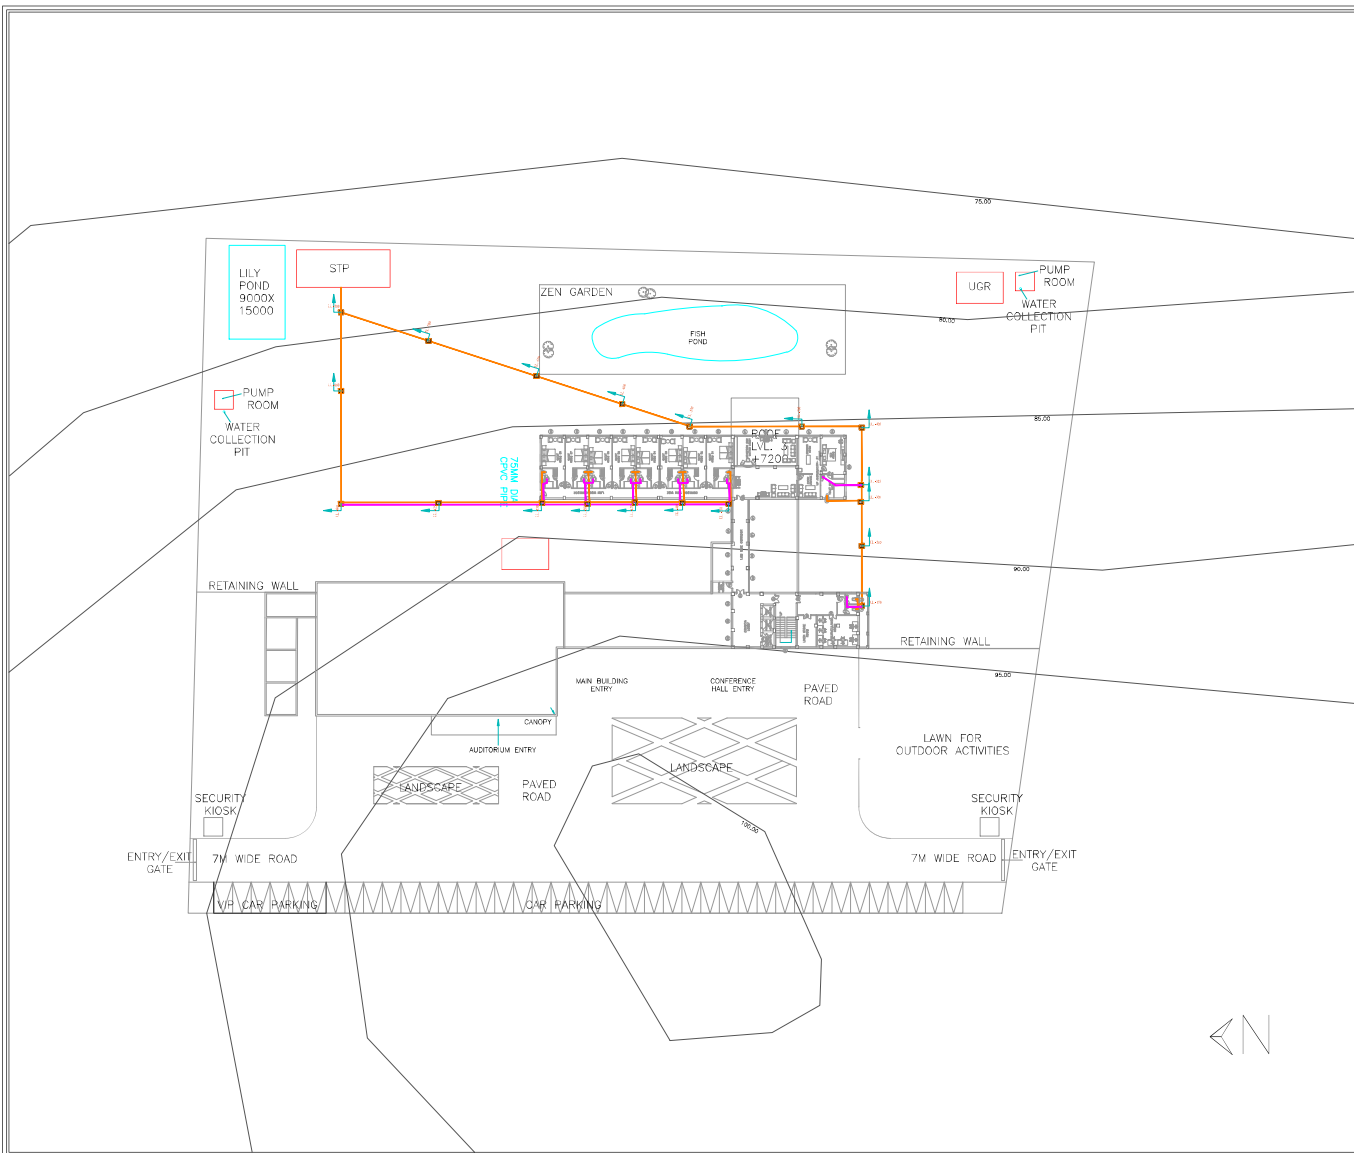

NOTE

	450x450mm CATCH BASIN
	600x600mm RECTANGULAR SEWERAGE MANHOLE
	SLOPE
	RAIN WATER HARVESTING TANK
	SEWERAGE PIPE
	RAIN WATER PIPE
	WASTE WATER PIPE
	DRAIN CHANNEL
	WATER SUPPLY
	INSPECTION PIT
	SPRINKLER

PROJECT TITLE :-
PROPOSED CONVENTION CENTER AT JONGLAPARA LOCALITY AT RESUBELPARA, NORTH GARO HILLS, MEGHALAYA-PHASE 2

CLIENT:
MEGHALAYA AGE LIMITED

FOR APPROVAL	RO		

DRAWING TITLE **MASTER PLAN**

DRAWING NO. :- AR24/MAL/C8/ROM/AR-01		SHEET NO. AR-01
SCALE: NTS	DATE: 23.09.24	REVISION NO. :-0
DRAWN BY:	DESIGNED BY:	APPROVED BY :- A.M.

ARCHITECTURAL CONSULTANT :-

ARCHOPOLIS

17/13, BAINNABGHATA ROAD, KOLKATA-700047

CONTACT: +91-9674590982; 9830504051
archopolis@gmail.com

THIS PRINT IS THE PROPERTY OF RESONANCE IT IS TO BE USED ONLY FOR THE PURPOSE FOR WHICH IT WAS LENT AND MUST NOT BE USED IN ANY WAY DETRIMENTAL TO THE INTEREST OF THIS COMPANY AND IS SUBJECT TO RETURN ON DEMAND

Symbols:-

100	Ball valve
10	Butterfly valve
10	Pressure gauge
10	Non return valve
10	Air Line
10	Water Line
10	Diffusers
10	MBBR Media
10	Multiport Valve

PROJECT TITLE :-

PROPOSED CONVENTION CENTER AT
JONGLAPARA LOCALITY AT
RESUBELPARA, NORTH GARO HILLS,
MEGHALAYA- PHASE I

CLIENT:

Meghalaya Age Limited

FOR APPROVAL

DRAWING TITLE

WATER SEDIMENT TREATMENT
SYSTEM

DRAWING NO. :-
AR24/MAL/C8/ROM/SNP-05

SHEET NO.
SNP-05

SCALE: **NTS** DATE: **24.08.24** REVISION NO. :-
01



DRAWN BY: DESIGNED BY: APPROVED BY :-
A.M.

ARCHITECTURAL CONSULTANT :-

ARCHOPOLIS
ARCHITECTURE • INTERIOR DESIGN • LANDSCAPE ARCHITECTURE • CIVIL ENGINEERING


17/13, BAINABGHATA ROAD, KOLKATA-700047

CONTACT: +91-9674590982; 9830504051
archopolis@gmail.com

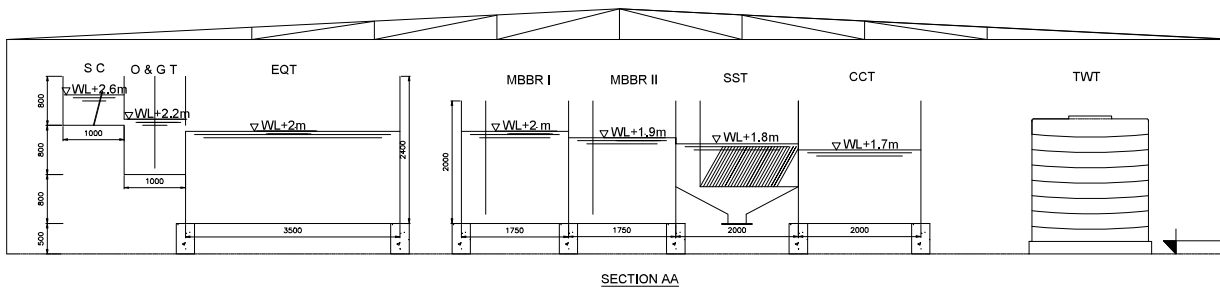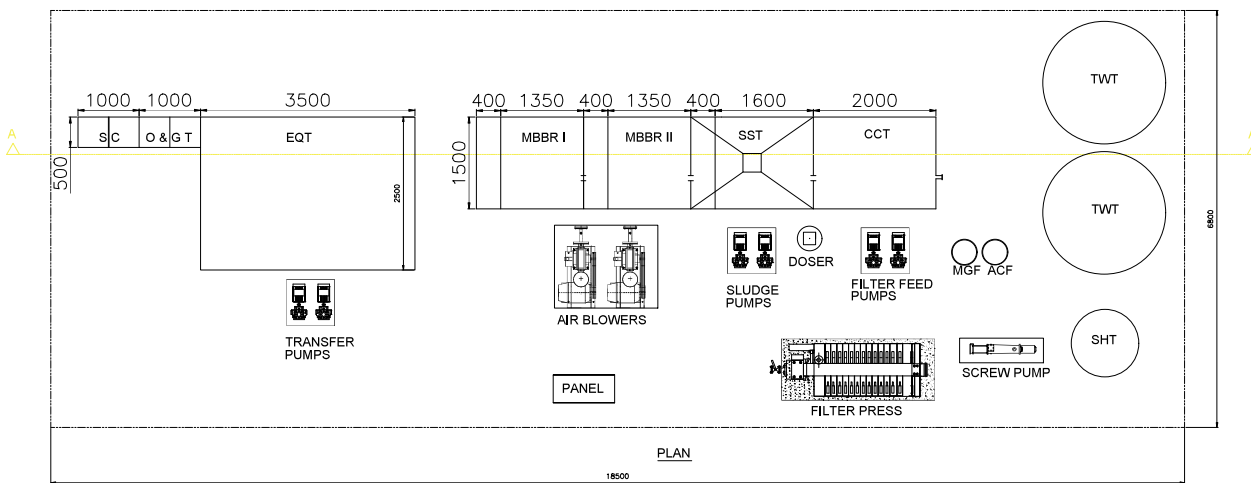

NOTE :- All dimensions are in mm if not otherwise mentioned

— Pre-fabricated MSEP structure (4 mm THK
with internally Epoxy Painted)

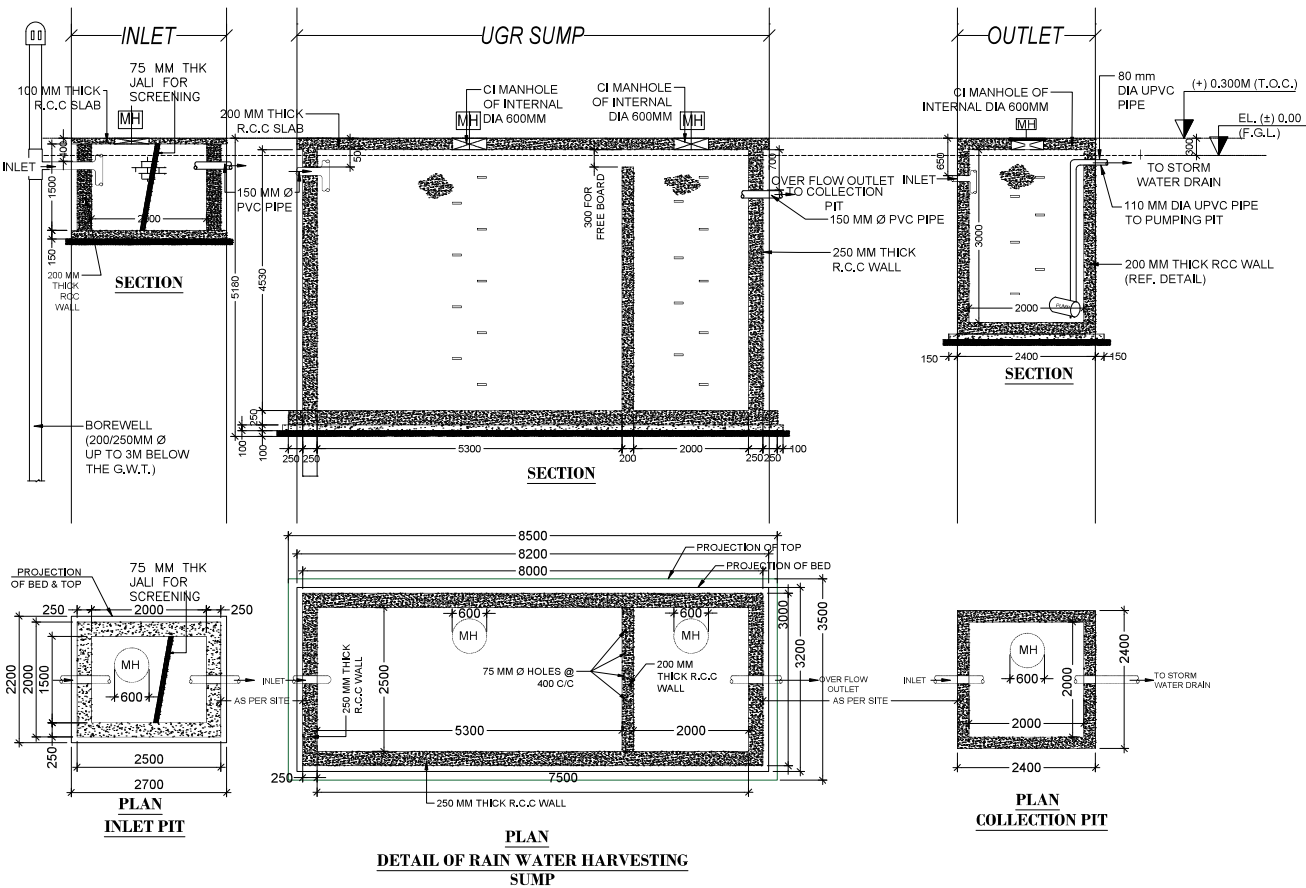

- NOTES :-**
1. ALL DIMENSIONS SHOWN ARE IN MM. (UNLESS MENTIONED).
 2. FOLLOW WRITTEN DIMENSIONS ONLY. DO NOT MEASURE ANY DIMENSION.
 3. 100MM TO 150MM THICK INTERNAL BAMBOO WALLS WITH THERMAL AND SOUND INSULATION.
 4. 150MM TO 175MM THICK EXTERNAL BAMBOO WALLS WITH THERMAL AND SOUND INSULATION.
 5. 115MM THICK BRICK WALL FOR TOILET.
 6. BAMBOO WALL THICKNESS MAY VARY.

PROJECT TITLE :-

PROPOSED CONVENTION CENTER AT JONGLAPARA LOCALITY AT RESUBELPARA, NORTH GARO HILLS, MEGHALAYA- PHASE I

CLIENT:

MEGHALAYAN AGE LTD.

FOR APPROVAL	RO		

DRAWING TITLE	UNDERGROUND RESERVOIR DETAIL		
DRAWING NO. :-	AR24/MALCK/ROM/UGR-01	SHEET NO.	TGR-01
SCALE:	DATE: 18/03/22	REVISION NO. :-	RO
DRAWN BY: SOMYANEEL	DESIGNED BY: PRABHA	APPROVED BY: PRABHA	
REF NO - ARCH/2021/MEGH/MAL/P-02			

ARCHITECTURAL CONSULTANT :-

ARCHOPOLIS

Ashadeep Tower, Flat No: A5
A.K. Azad Road, Guwahati-781008

17/13, BAISNABGHATA ROAD, KOLKATA-700047

CONTACT: +91- 9674590982; 9830504051
archopolis@gmail.com



WALL NUMBERS	THK	TYPE	REINFORCEMENT	
			OUTER FACE	INNER FACE
W1	250	2-Way	T8 @ 250	T8 @ 250
W2	250	2-Way	T8 @ 250	T8 @ 250
W3	200	2-Way	T8 @ 250	T8 @ 250

-
- NOTES :-

- 1 ALL DIMENSIONS SHOWN ARE IN MM, (UNLESS MENTIONED),
- 2 FOLLOW WRITTEN DIMENSIONS ONLY, DO NOT MEASURE ANY DIMENSION.
- 3 100MM TO 150MM THICK INTERNAL BAMBOO WALLS WITH THERMAL AND SOUND INSULATION,
- 4 150MM TO 175MM THICK EXTERNAL BAMBOO WALLS WITH THERMAL AND SOUND INSULATION,
- 5 115MM THICK BRICK WALL FOR TOILET .
- 6 BAMBOO WALL THICKNESS MAY VARY.

PROJECT TITLE :-

**PROPOSED CONVENTION CENTER AT
JONGLAPARA LOCALITY AT
RESUBELPARA, NORTH GARO HILLS,
MEGHALAYA- PHASE I**

CLIENT:

MEGHALAYAN AGE LTD.

[illegible]



DRAWING TITLE		UNDERGROUND RESERVOIR DETAIL (WALL DETAILS OF OHR SUMP)	
DRAWING NO. :-		AR24/MAL/CS/ROM/UGR-02	SHEET NO. :- UGR-02
SCALE:	DATE: 18.03.22	REVISION NO. -R0	
DRAWN BY:	DESIGNED BY:	APPROVED BY :-	
SOMYANEEL	FLANKA	FLANKA	
REF NO :- ARCH/2021/MEGH/MAL/P-02			

ARCHITECTURAL CONSULTANT :-



ARCHITECTURAL CONSULTANT :-

ARCHOPOLIS

:Ashadeep Tower,Flat No:A5
A.K.Azad Road,Guwahati-781008
:17/13, BAISNABGHATA ROAD, KOLKATA-700047

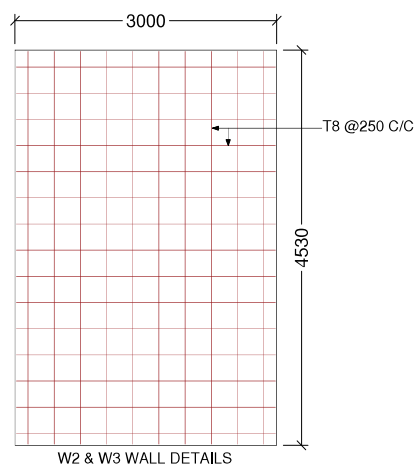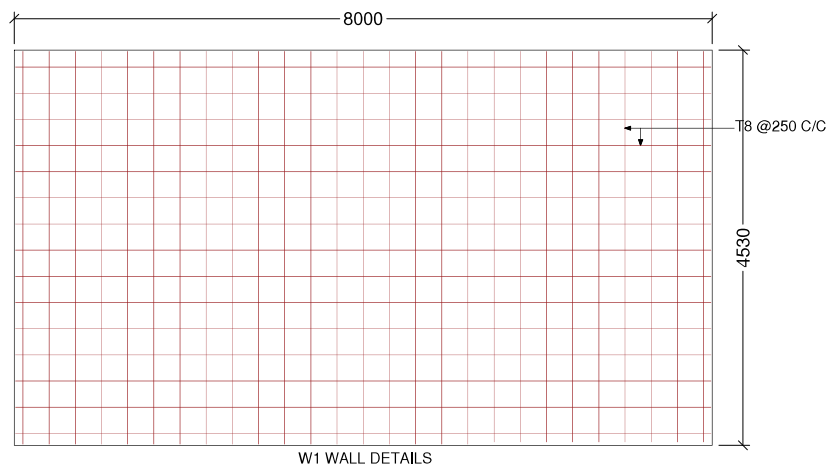

MAT FOOTING (F1) (M25 : FE500)

 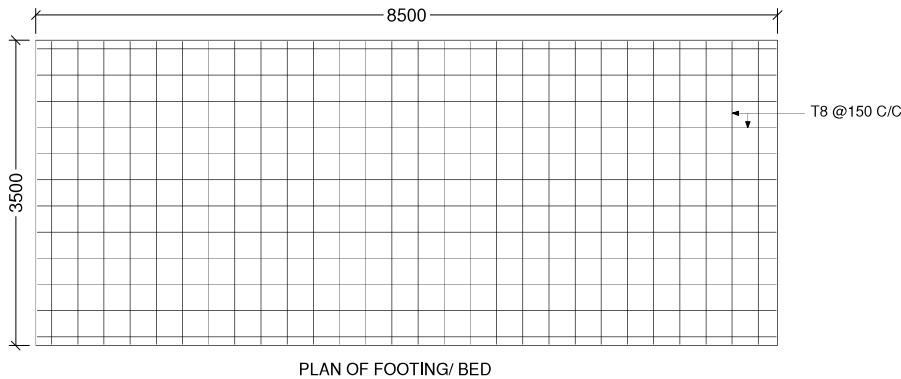

REINFORCEMENT DETAILS FOR FOOTING

FOOTING NUMBERS	THK	TYPE	REINFORCEMENT	
			OUTER FACE	INNER FACE
F1	250	2-Way	T8 @ 150	T8 @ 150

REINFORCEMENT DETAILS FOR TOP COVER

SLAB NUMBERS	THK	TYPE	BOTTOM REINFORCEMENT		TOP REINFORCEMENT		DISTRIBUTION
			SHORT SPAN (BENT UP)	LONG SPAN (BENT UP)	SS CONT.	LS CONT.	
TOP COVER	200	1-Way	T8 @ 300	--	T8 @ 300	--	T8 @ 300

NOTES :-

1. ALL DIMENSIONS SHOWN ARE IN MM, (UNLESS MENTIONED).
2. FOLLOW WRITTEN DIMENSIONS ONLY, DO NOT MEASURE ANY DIMENSION.
3. 100MM TO 150MM THICK INTERNAL BAMBOO WALLS WITH THERMAL AND SOUND INSULATION.
4. 150MM TO 175MM THICK EXTERNAL BAMBOO WALLS WITH THERMAL AND SOUND INSULATION.
5. 115MM THICK BRICK WALL FOR TOILET.
6. BAMBOO WALL THICKNESS MAY VARY.

PROJECT TITLE :-

PROPOSED CONVENTION CENTER AT JONGLAPARA LOCALITY AT RESUBELPARA, NORTH GARO HILLS, MEGHALAYA- PHASE I

CLIENT:

MEGHALAYAN AGE LTD.

FOR APPROVAL

RO			

DRAWING TITLE UNDERGROUND RESERVOIR DETAIL (FOOTING DETAILS OF OHR SUMP)

DRAWING NO. :- AR24/MAL/CB/ROM/UGR-01 SHEET NO. UGR-03

SCALE: DATE: 18/03/22 REVISION NO. :-R0

DRAWN BY: SOMYANIEL DESIGNED BY: ELABKA APPROVED BY: ELABKA

REF NO- ARCH/2021/MEGH/MAL/P-02

ARCHITECTURAL CONSULTANT :-



ARCHOPOLIS

:Ashdeep Tower,Flat No:A5
A.K.Azad Road,Guwahati-781008

:17/13, BAISNABGHATA ROAD, KOLKATA-700047

CONTACT: +91- 9674590982; 9830504051
archopolis@gmail.com

INLET (RWH) POCKET DETAIL

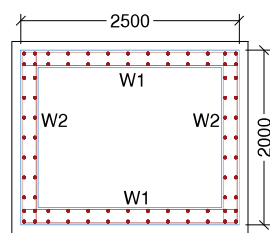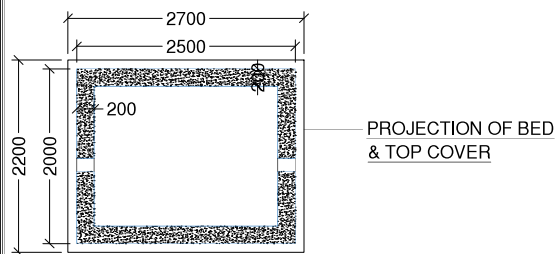

PLAN (BELOW TOP)

REINFORCEMENT DETAILS FOR TOP COVER


SLAB NUMBERS	THK	TYPE	BOTTOM REINFORCEMENT		TOP REINFORCEMENT		DISTRIBUTION
			SHORT SPAN (BENT UP)	LONG SPAN (BENT UP)	SS CONT.	LS CONT.	
TOP COVER	100	1-Way	T8 @ 300	--	T8 @ 300	--	T8 @ 300

REINFORCEMENT DETAILS FOR FOOTING


FOOTING NUMBERS	THK	TYPE	REINFORCEMENT	
			OUTER FACE	INNER FACE
F1	150	2-Way	T8 @ 150	T8 @ 150

REINFORCEMENT DETAILS FOR WALL

WALL NUMBERS	THK	TYPE	REINFORCEMENT	
			OUTER FACE	INNER FACE
W1	200	2-Way	T8 @ 250	T8 @ 250
W2	200	2-Way	T8 @ 250	T8 @ 250

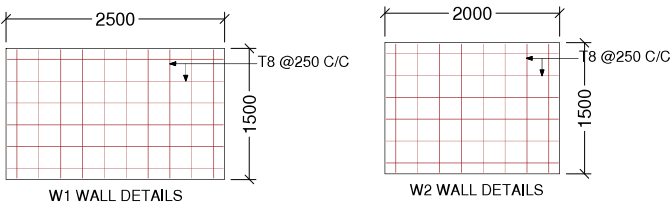

MAT FOOTING (F1) (M25 : FE500)

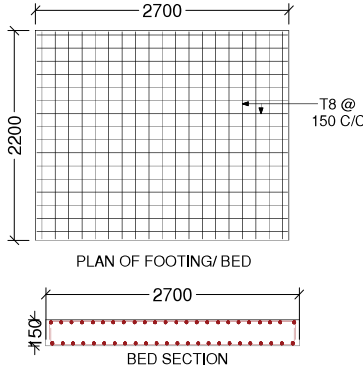

NOTES :-

- 1 ALL DIMENSIONS SHOWN ARE IN MM, (UNLESS MENTIONED).
- 2 FOLLOW WRITTEN DIMENSIONS ONLY, DO NOT MEASURE ANY DIMENSION.
- 3 100MM TO 150MM THICK INTERNAL BAMBOO WALLS WITH THERMAL AND SOUND INSULATION,
- 4 150MM TO 175MM THICK EXTERNAL BAMBOO WALLS WITH THERMAL AND SOUND INSULATION,
- 5 115MM THICK BRICK WALL FOR TOILET ,
- 6 BAMBOO WALL THICKNESS MAY VARY,

PROJECT TITLE :-

PROPOSED CONVENTION CENTER AT
JONGLAPARA LOCALITY AT
RESUBELPARA, NORTH GARO HILLS,
MEGHALAYA- PHASE I

CLIENT:

MEGHALAYAN AGE LTD.

FOR APPROVAL

RO			

DRAWING TITLE

UNDERGROUND RESERVOIR DETAIL
(STRUCTURAL DETAILS OF INLET TANK)

DRAWING NO. - AR24/MAL/CRROM/UGR-01 (SHEET NO. 1 OF 04)

SCALE: DATE: 18.03.22 REVISION NO. - 01



DRAWN BY: SOMYANIEL DESIGNED BY: PIANKA APPROVED BY: PIANKA

REF NO - ARCH/2021/MEGH/MAL/P-02


ARCHITECTURAL CONSULTANT -

ARCHOPOLIS
ARCHITECTS • INTERIOR DESIGNERS • LANDSCAPE ARCHITECTS • PROJECT MANAGERS • FURNITURE DESIGNERS
:Ashadeep Tower, Flat No: A5
A.K. Azad Road, Guwahati-781008
:17/13, BAINABGHATA ROAD, KOLKATA-700047
CONTACT: +91- 9674590982; 9830504051
archopolis@gmail.com

OUTLET (RWH) POCKET DETAIL

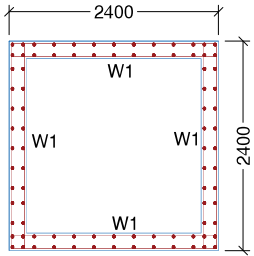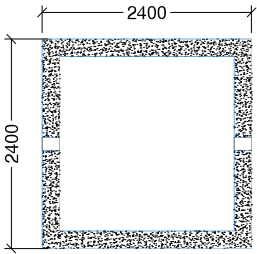

PLAN (BELOW TOP)

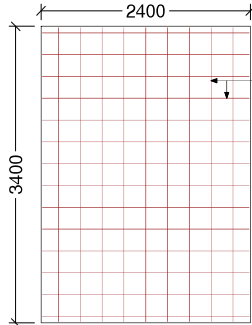


W1 WALL DETAILS


T8 @ 250 C/C

REINFORCEMENT DETAILS FOR WALL

WALL NUMBERS	THK	TYPE	REINFORCEMENT	
			OUTER FACE	INNER FACE
W1	200	2-Way	T8 @ 250	T8 @ 250

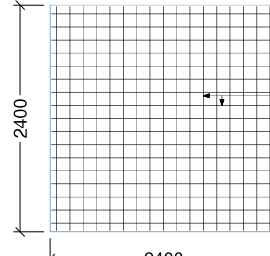

PLAN OF FOOTING/ BED

 

BED SECTION

REINFORCEMENT DETAILS FOR TOP COVER

SLAB NUMBERS	THK	TYPE	BOTTOM REINFORCEMENT		TOP REINFORCEMENT		DISTRIBUTION
			SHORT SPAN (BENT UP)	LONG SPAN (BENT UP)	SS CONT.	LS CONT.	
TOP COVER	200	1-Way	T8 @ 300	--	T8 @ 300	--	T8 @ 300

REINFORCEMENT DETAILS FOR FOOTING

FOOTING NUMBERS	THK	TYPE	REINFORCEMENT	
			OUTER FACE	INNER FACE
F1	200	2-Way	T8 @ 150	T8 @ 150

NOTES :-

1. ALL DIMENSIONS SHOWN ARE IN MM, (UNLESS MENTIONED).
2. FOLLOW WRITTEN DIMENSIONS ONLY, DO NOT MEASURE ANY DIMENSION.
3. 100MM TO 150MM THICK INTERNAL BAMBOO WALLS WITH THERMAL AND SOUND INSULATION.
4. 150MM TO 175MM THICK EXTERNAL BAMBOO WALLS WITH THERMAL AND SOUND INSULATION.
5. 115MM THICK BRICK WALL FOR TOILET.
6. BAMBOO WALL THICKNESS MAY VARY.

PROJECT TITLE :-

PROPOSED CONVENTION CENTER AT
JONGLA PARA LOCALITY AT
RESUBEL PARA, NORTH GARO HILLS,
MEGHALAYA- PHASE I

CLIENT:

MEGHALAYAN AGE LTD.

FOR APPROVAL

RO			

DRAWING TITLE

UNDERGROUND RESERVOIR DETAIL
(STRUCTURAL DETAILS OF OUTLET TANK)

DRAWING NO. :- AR24/MAL/CR/ROM/UGR-04 SHEET NO. UGR-05

SCALE: DATE: 18/03/22 REVISION NO. :-R0

DRAWN BY: SOMYANIEL DESIGNED BY: PRABHA APPROVED BY: PRABHA

REF NO.- ARCH/2021/MEGH/MAL/P-02


ARCHITECTURAL CONSULTANT :-

ARCHOPOLIS

:Ashadeep Tower,Flat No:A5
A.K.Azad Road,Guwahati-781008

:17/13, BAISNABGHATA ROAD, KOLKATA-700047

CONTACT: +91- 9674590982; 9830504051
archopolis@gmail.com

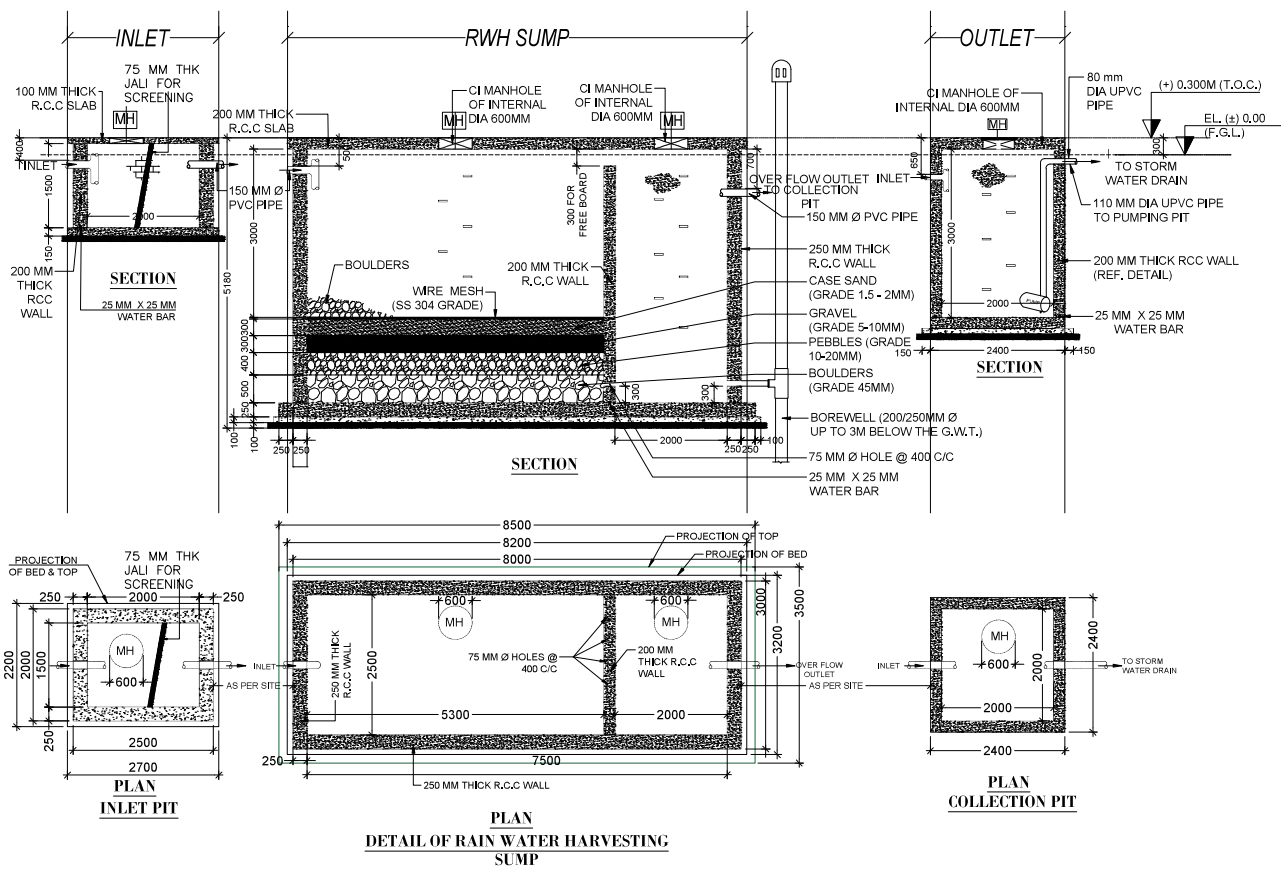

PROJECT TITLE :-
**PROPOSED CONVENTION CENTER AT
 JONGLAPARA LOCALITY AT
 RESUBELPARA, NORTH GARO HILLS,
 MEGHALAYA- PHASE I**

CLIENT:
MEGHALAYA AGE LIMITED

FOR APPROVAL	RO		


DRAWING TITLE **RAIN WATER HARVESTING**

DRAWING NO. :- **AR24/MAL/C8/ROM/RW-01** SHEET NO. **RW-01**

SCALE: **NTS** DATE: **23.09.24** REMISION NO. :- **40**



DRAWN BY: DESIGNED BY: APPROVED BY: **A.M.**

ARCHITECTURAL CONSULTANT :-
ARCHOPOLIS
 17/13, BAINABGHATA ROAD, KOLKATA-700047
 CONTACT: +91-9674590982; 9830504051
 archopolis@gmail.com

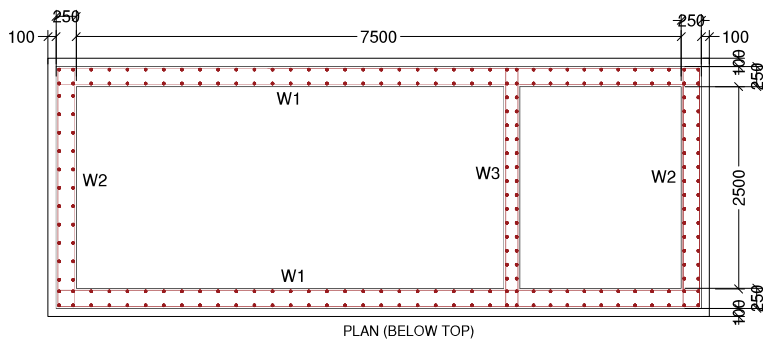

REINFORCEMENT DETAILS FOR WALL

WALL NUMBERS	THK	TYPE	REINFORCEMENT	
			OUTER FACE	INNER FACE
W1	250	2-Way	T8 @ 250	T8 @ 250
W2	250	2-Way	T8 @ 250	T8 @ 250
W3	200	2-Way	T8 @ 250	T8 @ 250

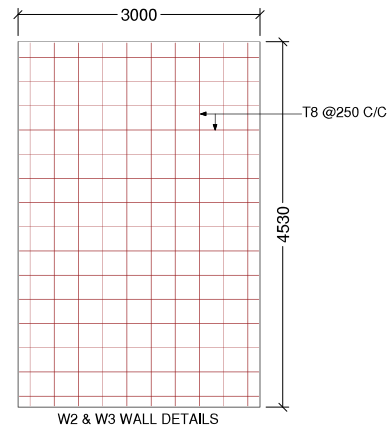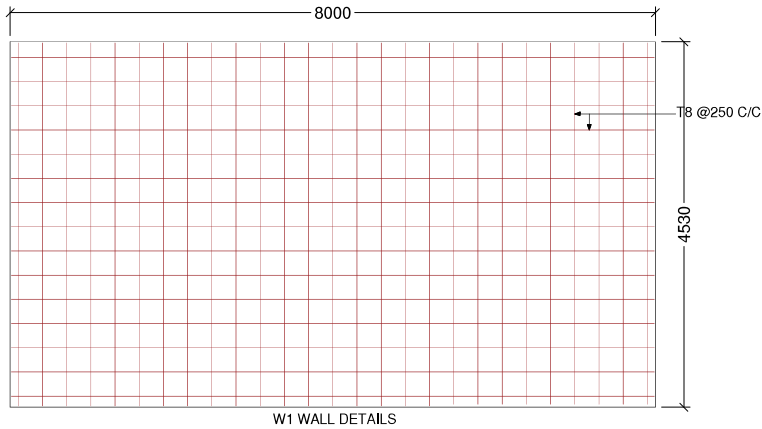

PROJECT TITLE :-

PROPOSED CONVENTION CENTER AT
JONGLAPARA LOCALITY AT
RESUBELPARA, NORTH GARO HILLS,
MEGHALAYA- PHASE I

CLIENT:

MEGHALAYA AGE LIMITED

FOR APPROVAL

RO		

DRAWING TITLE

RAIN WATER HARVESTING

DRAWING NO. :-

AR24/MAL/C8/ROM/RW-02

SHEET NO.

RW-02

SCALE:

NTS

DATE:

23.09.24

REVISION NO. :-0

DRAWN BY:

DESIGNED BY:

APPROVED BY :-

A.M.

ARCHITECTURAL CONSULTANT :-

 

ARCHOPOLIS

17/13, BAINABGHATA ROAD, KOLKATA-700047

CONTACT: +91-9674590982; 9830504051

archopolis@gmail.com

MAT FOOTING (F1) (M25 : FE500)

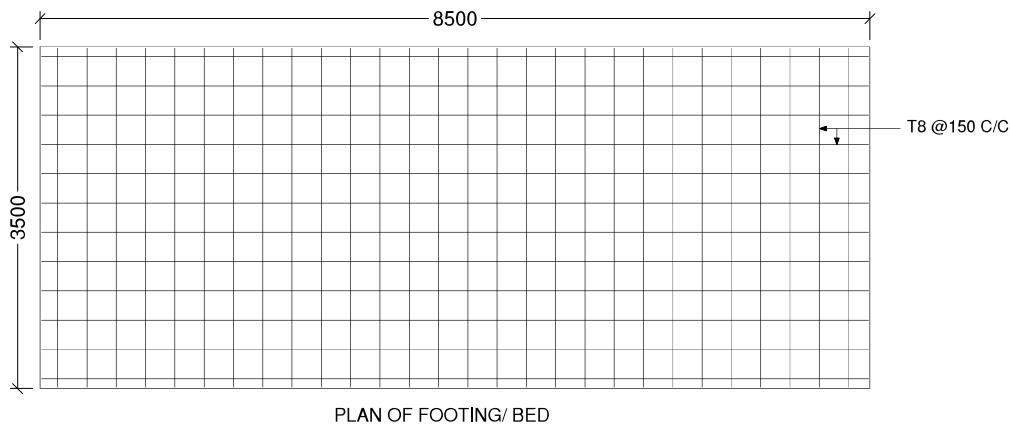

REINFORCEMENT DETAILS FOR FOOTING

FOOTING NUMBERS	THK	TYPE	REINFORCEMENT	
			OUTER FACE	INNER FACE
F1	250	2-Way	T8 @ 150	T8 @ 150

REINFORCEMENT DETAILS FOR TOP COVER

SLAB NUMBERS	THK	TYPE	BOTTOM REINFORCEMENT		TOP REINFORCEMENT		DISTRIBUTION
			SHORT SPAN (BENT UP)	LONG SPAN (BENT UP)	SS CONT.	LS CONT.	
TOP COVER	200	1-Way	T8 @ 300	--	T8 @ 300	--	T8 @ 300

PROJECT TITLE :-

PROPOSED CONVENTION CENTER AT
JONGLAPARA LOCALITY AT
RESUBELPARA, NORTH GARO HILLS,
MEGHALAYA- PHASE I

CLIENT:

MEGHALAYA AGE LIMITED

FOR APPROVAL

DRAWING TITLE

RAIN WATER HARVESTING

DRAWING NO. :-

AR24/MAL/C8/ROM/RW-03

SHEET NO.

RW-03

SCALE:

NTS

DATE:

23.09.24

REVISION NO. :-0

DRAWN BY:

DESIGNED BY:

APPROVED BY :-

A.M.


ARCHITECTURAL CONSULTANT :-

ARCHOPOLIS


17/13, BAINABGHATA ROAD, KOLKATA-700047

CONTACT: +91-9674590982; 9830504051
archopolis@gmail.com

INLET (RWH) POCKET DETAIL

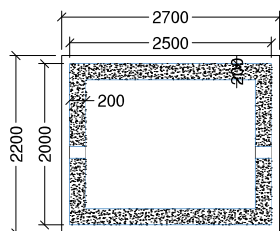

PROJECTION OF BED & TOP COVER

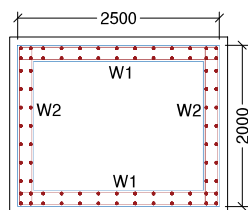

PLAN (BELOW TOP)

REINFORCEMENT DETAILS FOR TOP COVER


SLAB NUMBERS	THK	TYPE	BOTTOM REINFORCEMENT		TOP REINFORCEMENT		DISTRIBUTION
			SHORT SPAN (BENT UP)	LONG SPAN (BENT UP)	SS CONT.	LS CONT.	
TOP COVER	100	1-Way	T8 @ 300	--	T8 @ 300	--	T8 @ 300

REINFORCEMENT DETAILS FOR FOOTING


FOOTING NUMBERS	THK	TYPE	REINFORCEMENT	
			OUTER FACE	INNER FACE
F1	150	2-Way	T8 @ 150	T8 @ 150

REINFORCEMENT DETAILS FOR WALL

WALL NUMBERS	THK	TYPE	REINFORCEMENT	
			OUTER FACE	INNER FACE
W1	200	2-Way	T8 @ 250	T8 @ 250
W2	200	2-Way	T8 @ 250	T8 @ 250

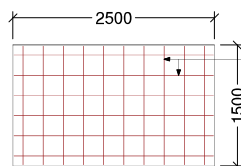


W1 WALL DETAILS

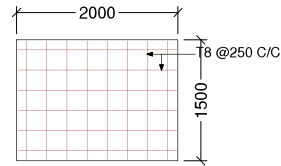

W2 WALL DETAILS

MAT FOOTING (F1) (M25 : FE500)

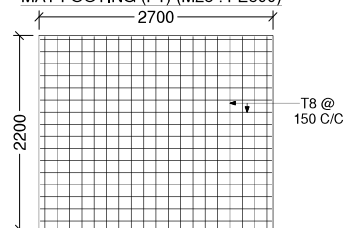

PLAN OF FOOTING/ BED



BED SECTION

PROJECT TITLE :-

PROPOSED CONVENTION CENTER AT
JONGLAPARA LOCALITY AT
RESUBELPARA, NORTH GARO HILLS,
MEGHALAYA- PHASE I

CLIENT:

MEGHALAYA AGE LIMITED

FOR APPROVAL

RO		

DRAWING TITLE

RAIN WATER HARVESTING

DRAWING NO. :-

AR24/MAL/C8/ROM/RW-04

SHEET NO.

RW-04

SCALE:

NTS

DATE:

23.09.24

REVISION NO. -#0

DRAWN BY:

DESIGNED BY:

APPROVED BY :-

A.M.



ARCHITECTURAL CONSULTANT :-

ARCHOPOLIS

17/13, BAINABGHATA ROAD, KOLKATA-700047

CONTACT: +91-9674590982; 9830504051
archopolis@gmail.com

OUTLET (RWH) POCKET DETAIL

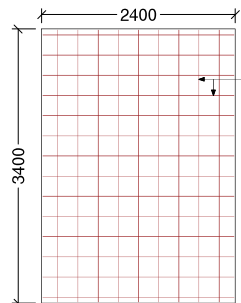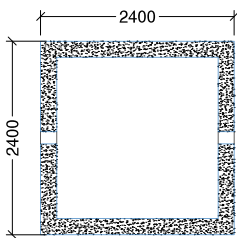


W1 WALL DETAILS


T8 @ 250 C/C

REINFORCEMENT DETAILS FOR WALL


WALL NUMBERS	THK	TYPE	REINFORCEMENT	
			OUTER FACE	INNER FACE
W1	200	2-Way	T8 @ 250	T8 @ 250

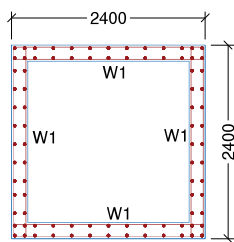

PLAN (BELOW TOP)

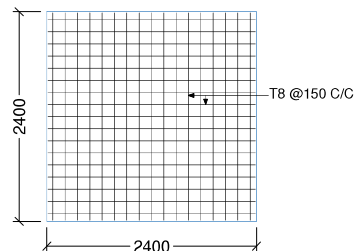

PLAN OF FOOTING/ BED

 

BED SECTION

REINFORCEMENT DETAILS FOR TOP COVER

SLAB NUMBERS	THK	TYPE	BOTTOM REINFORCEMENT		TOP REINFORCEMENT		DISTRIBUTION
			SHORT SPAN (BENT UP)	LONG SPAN (BENT UP)	SS CONT.	LS CONT.	
TOP COVER	200	1-Way	T8 @ 300	--	T8 @ 300	--	T8 @ 300

REINFORCEMENT DETAILS FOR FOOTING

FOOTING NUMBERS	THK	TYPE	REINFORCEMENT	
			OUTER FACE	INNER FACE
F1	200	2-Way	T8 @ 150	T8 @ 150

PROJECT TITLE :-

PROPOSED CONVENTION CENTER AT
JONGLAPARA LOCALITY AT
RESUBELPARA, NORTH GARO HILLS,
MEGHALAYA- PHASE I

CLIENT:

MEGHALAYA AGE LIMITED

FOR APPROVAL

RO		

DRAWING TITLE

RAIN WATER HARVESTING

DRAWING NO. :-

AR24/MAL/C8/ROM/RW-05

SHEET NO.

RW-05

SCALE:

NTS

DATE:

23.09.24

REVISION NO. :-0

DRAWN BY:

DESIGNED BY:

APPROVED BY :-

A.M.

ARCHITECTURAL CONSULTANT :-

ARCHOPOLIS

17/13, BAINABGHATA ROAD, KOLKATA-700047

CONTACT: +91-9674590982; 9830504051

archopolis@gmail.com